



General Arrangement 2L-25

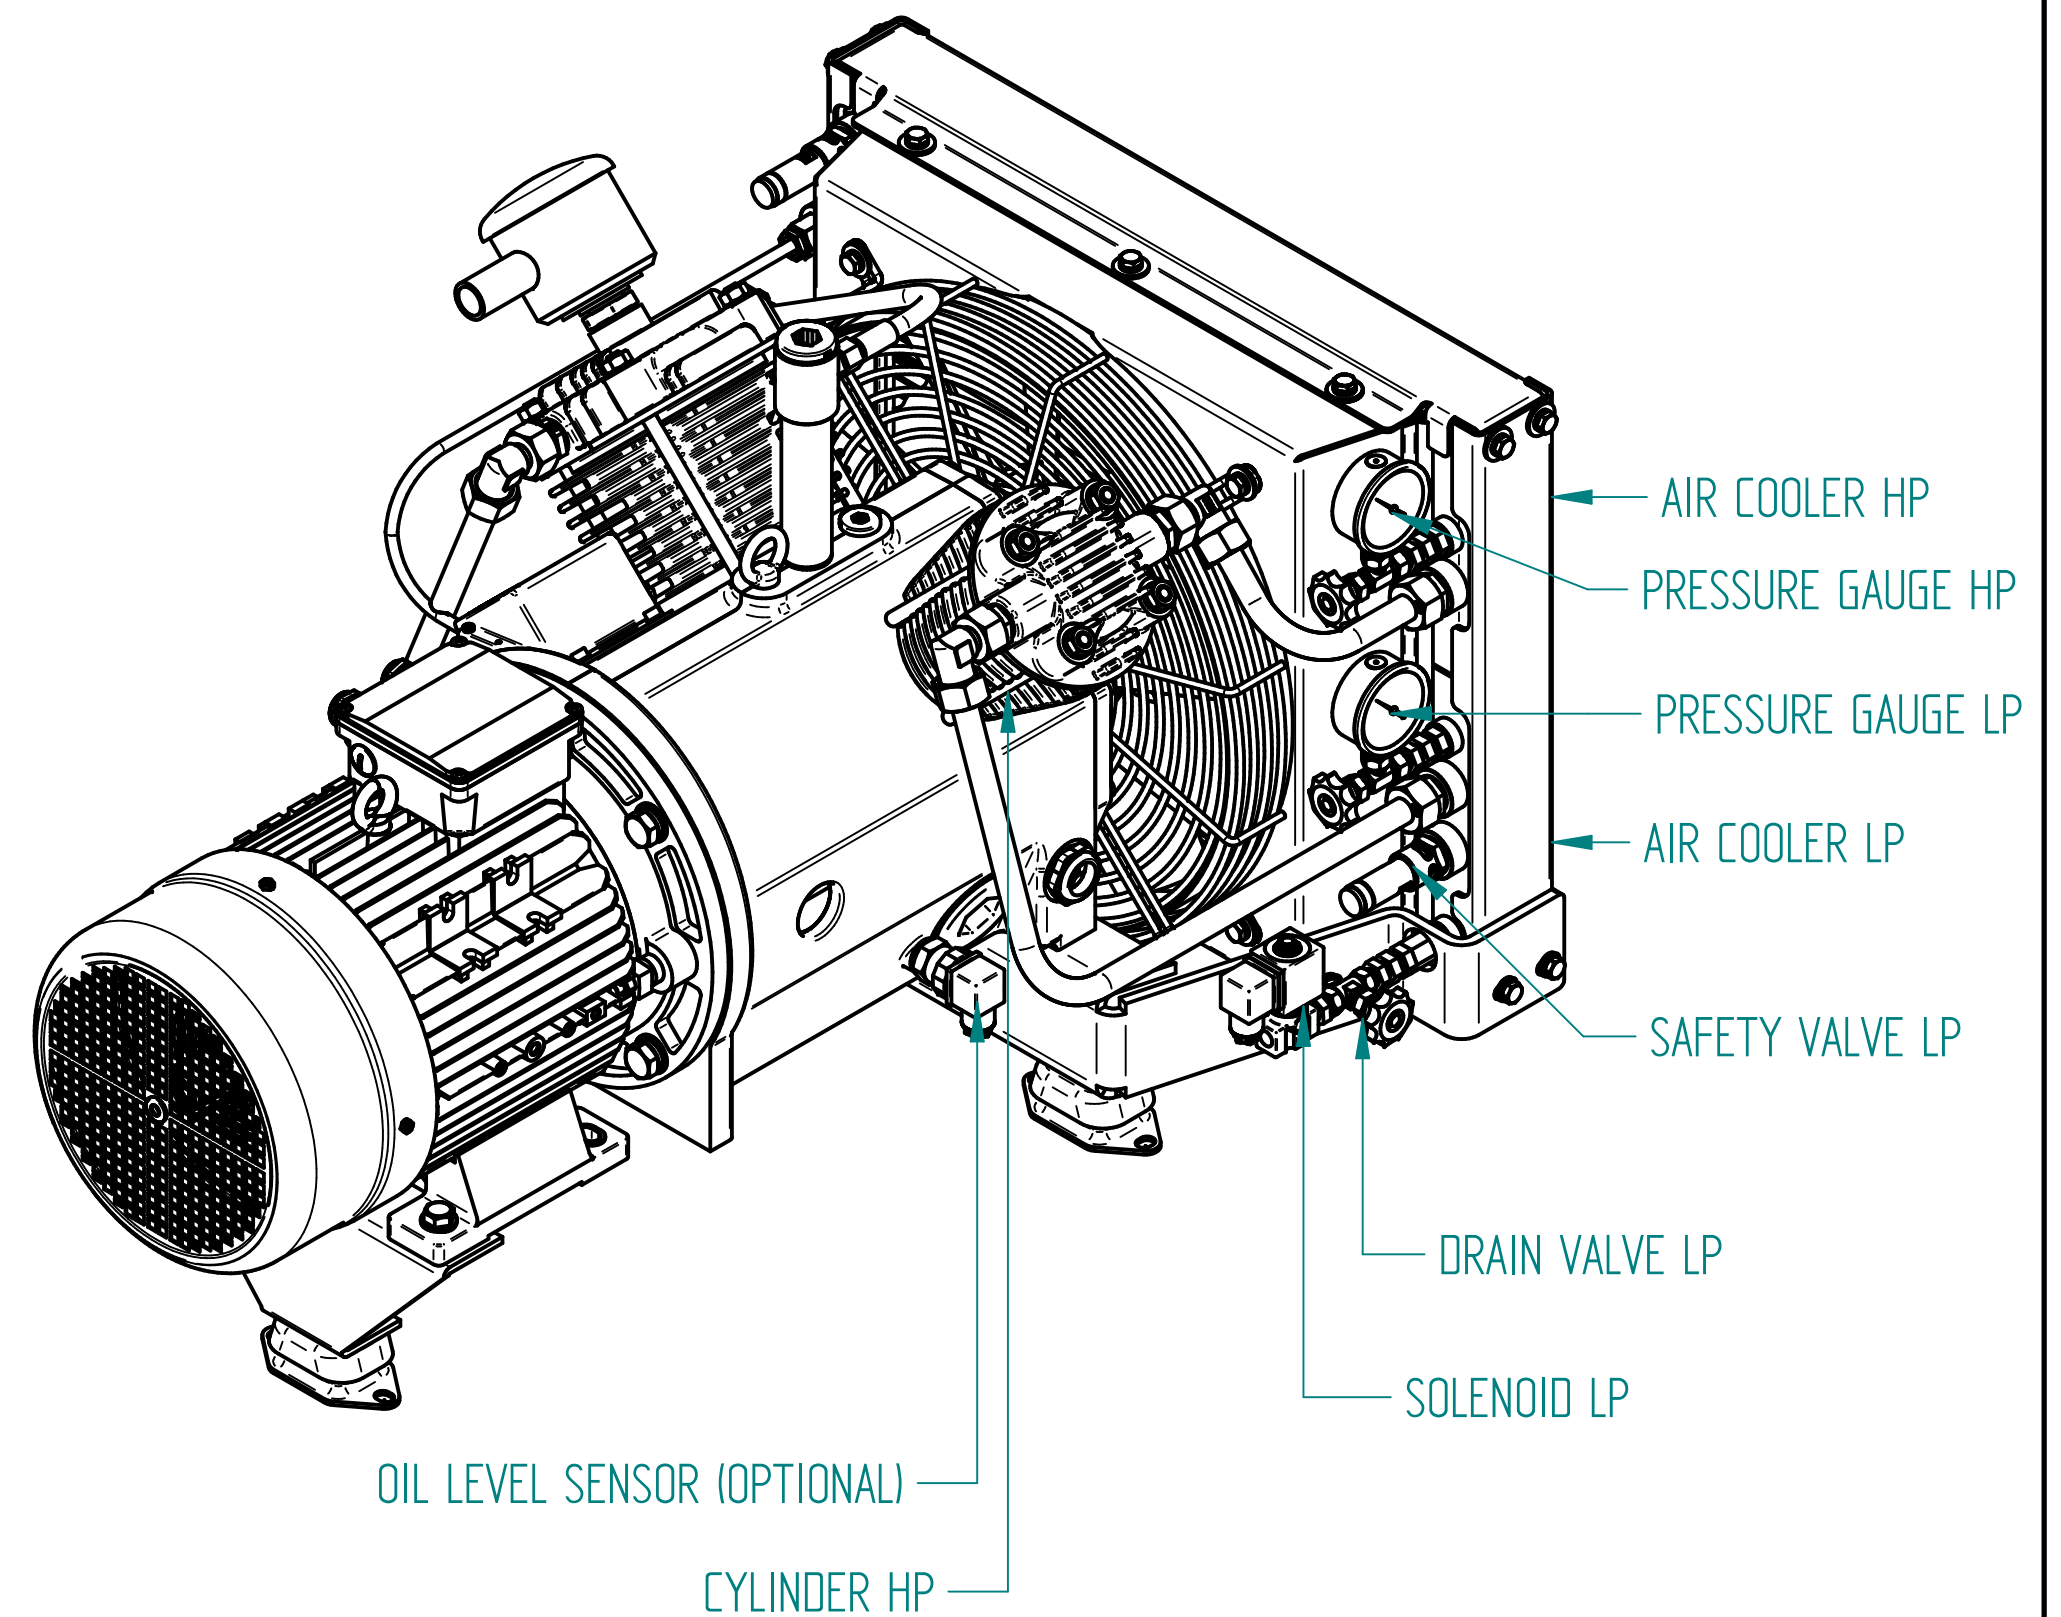

Minimum service area on all sides = 0.5 m

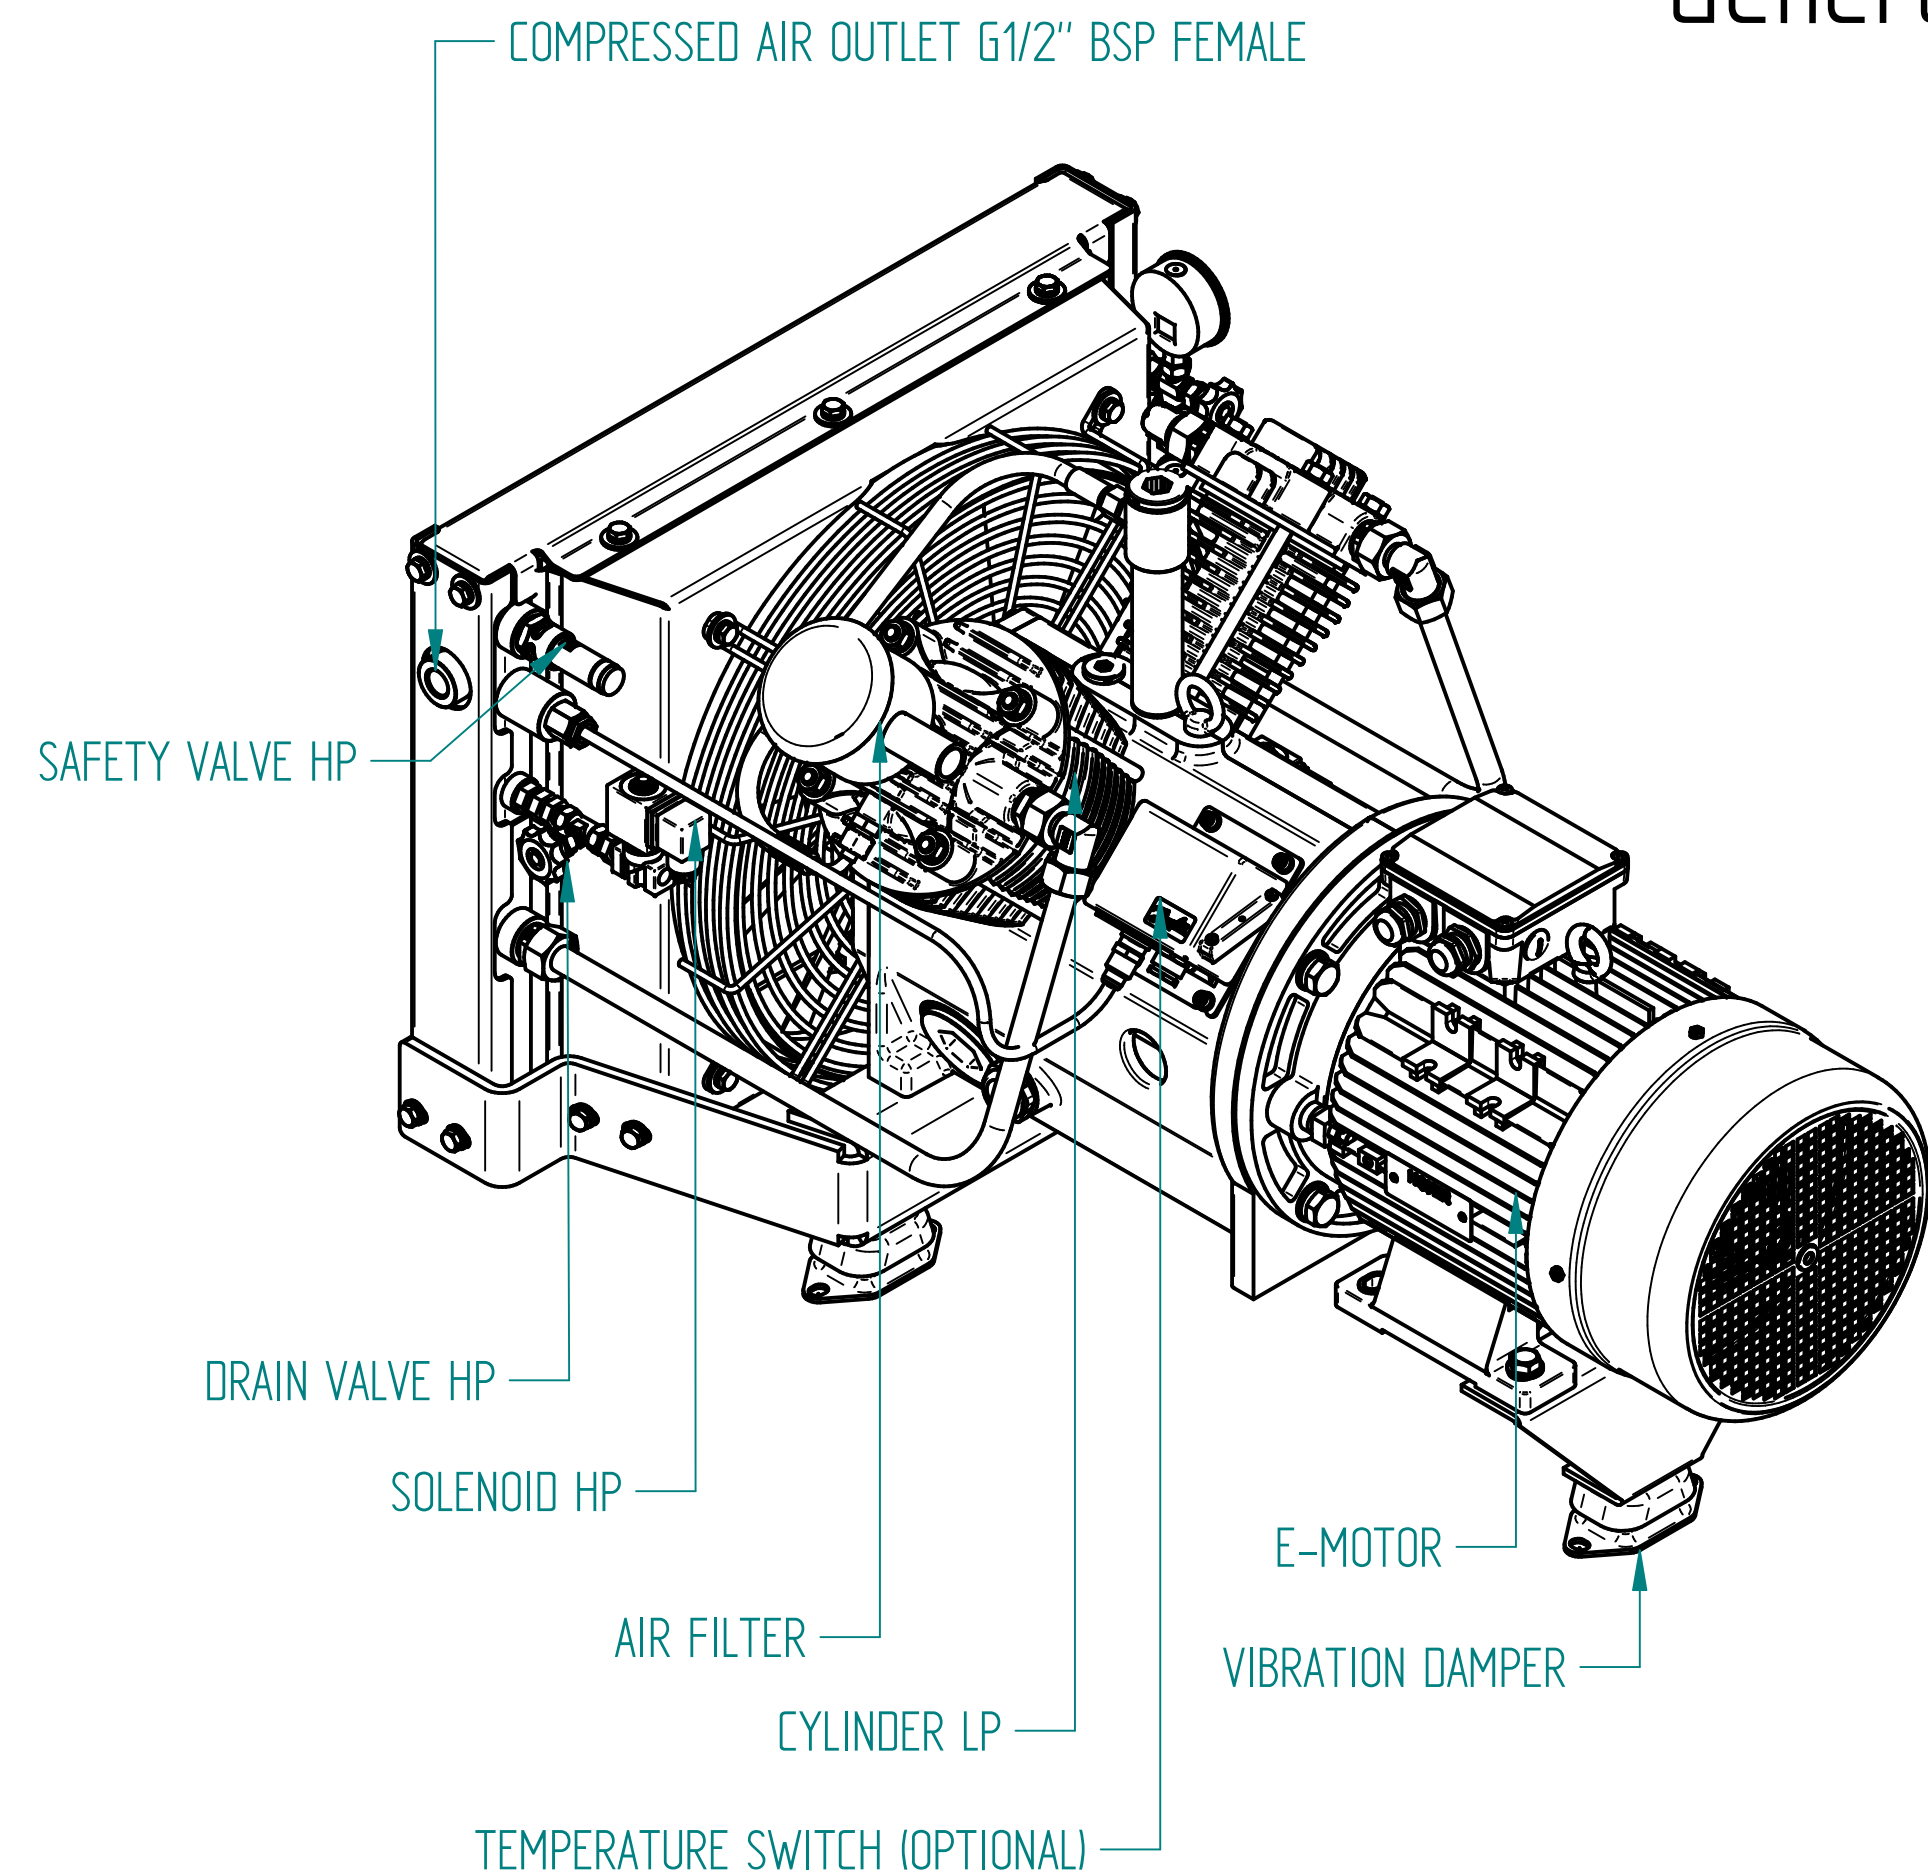




NAMES OF OUTSIDE PARTS

	NAME:	DATE:
DRAWN:	RDK	29/08/19
DRAWING NAME:	GA-2L-25-132S-Optional-rev1.dft	
DRAWING TYPE:	GENERAL ARRANGEMENT	

DENO compressors B.V.
www.denocomp.nl
info@denocomp.nl

SCALE: 1:5

SIZE: A2

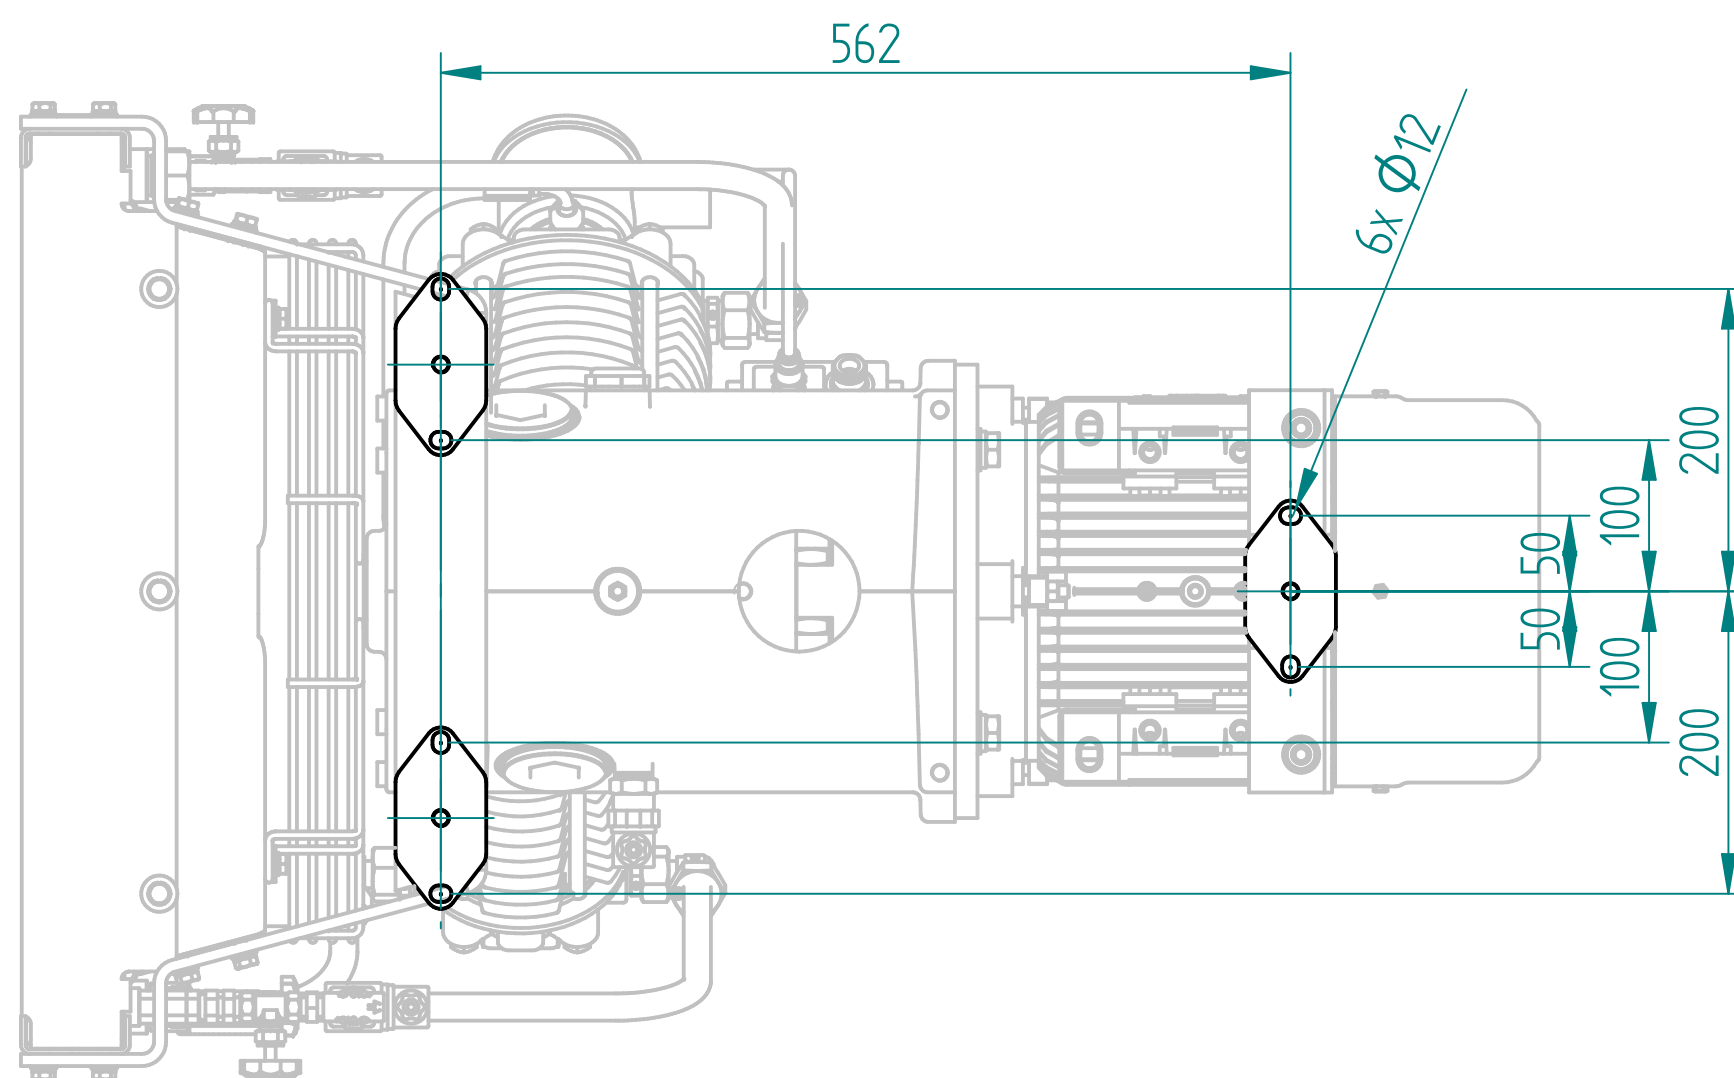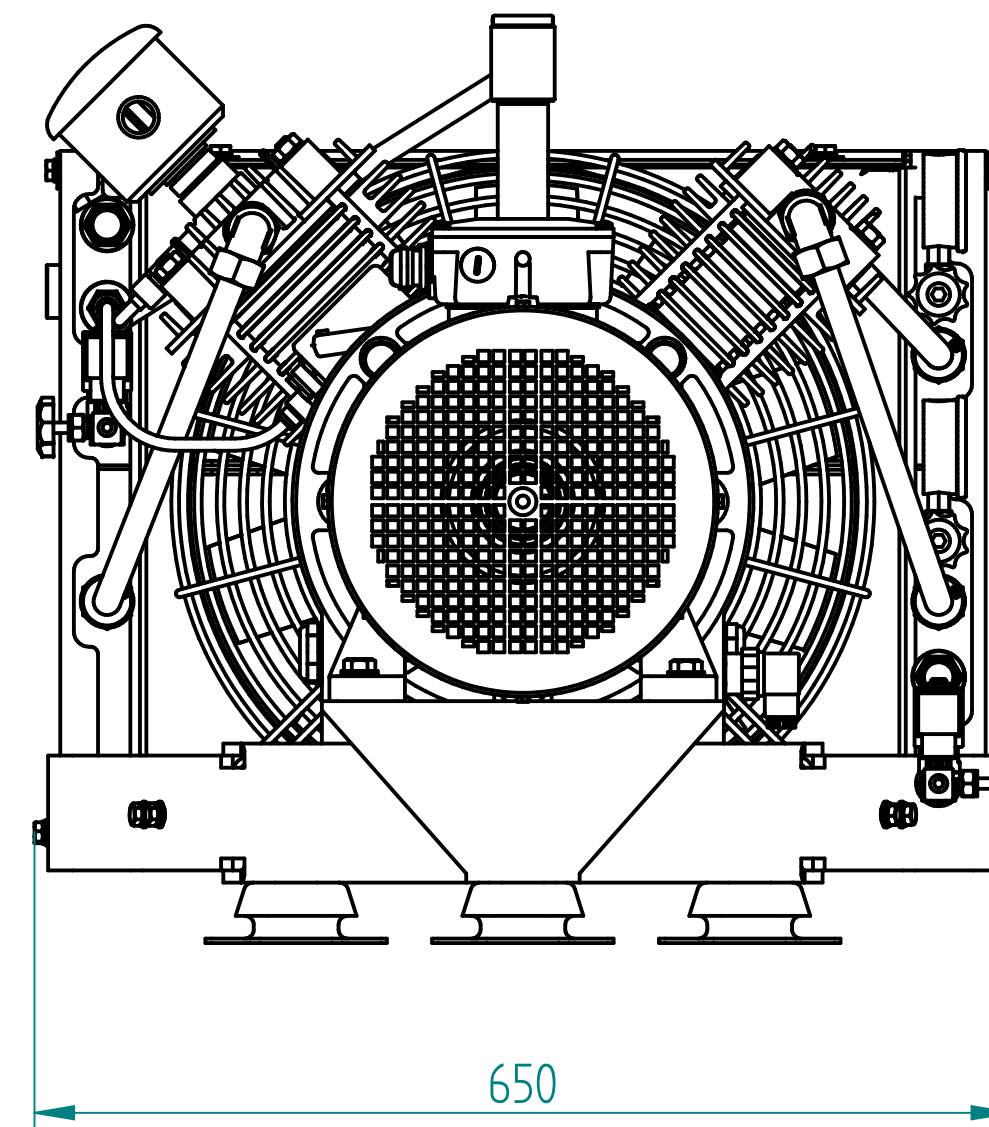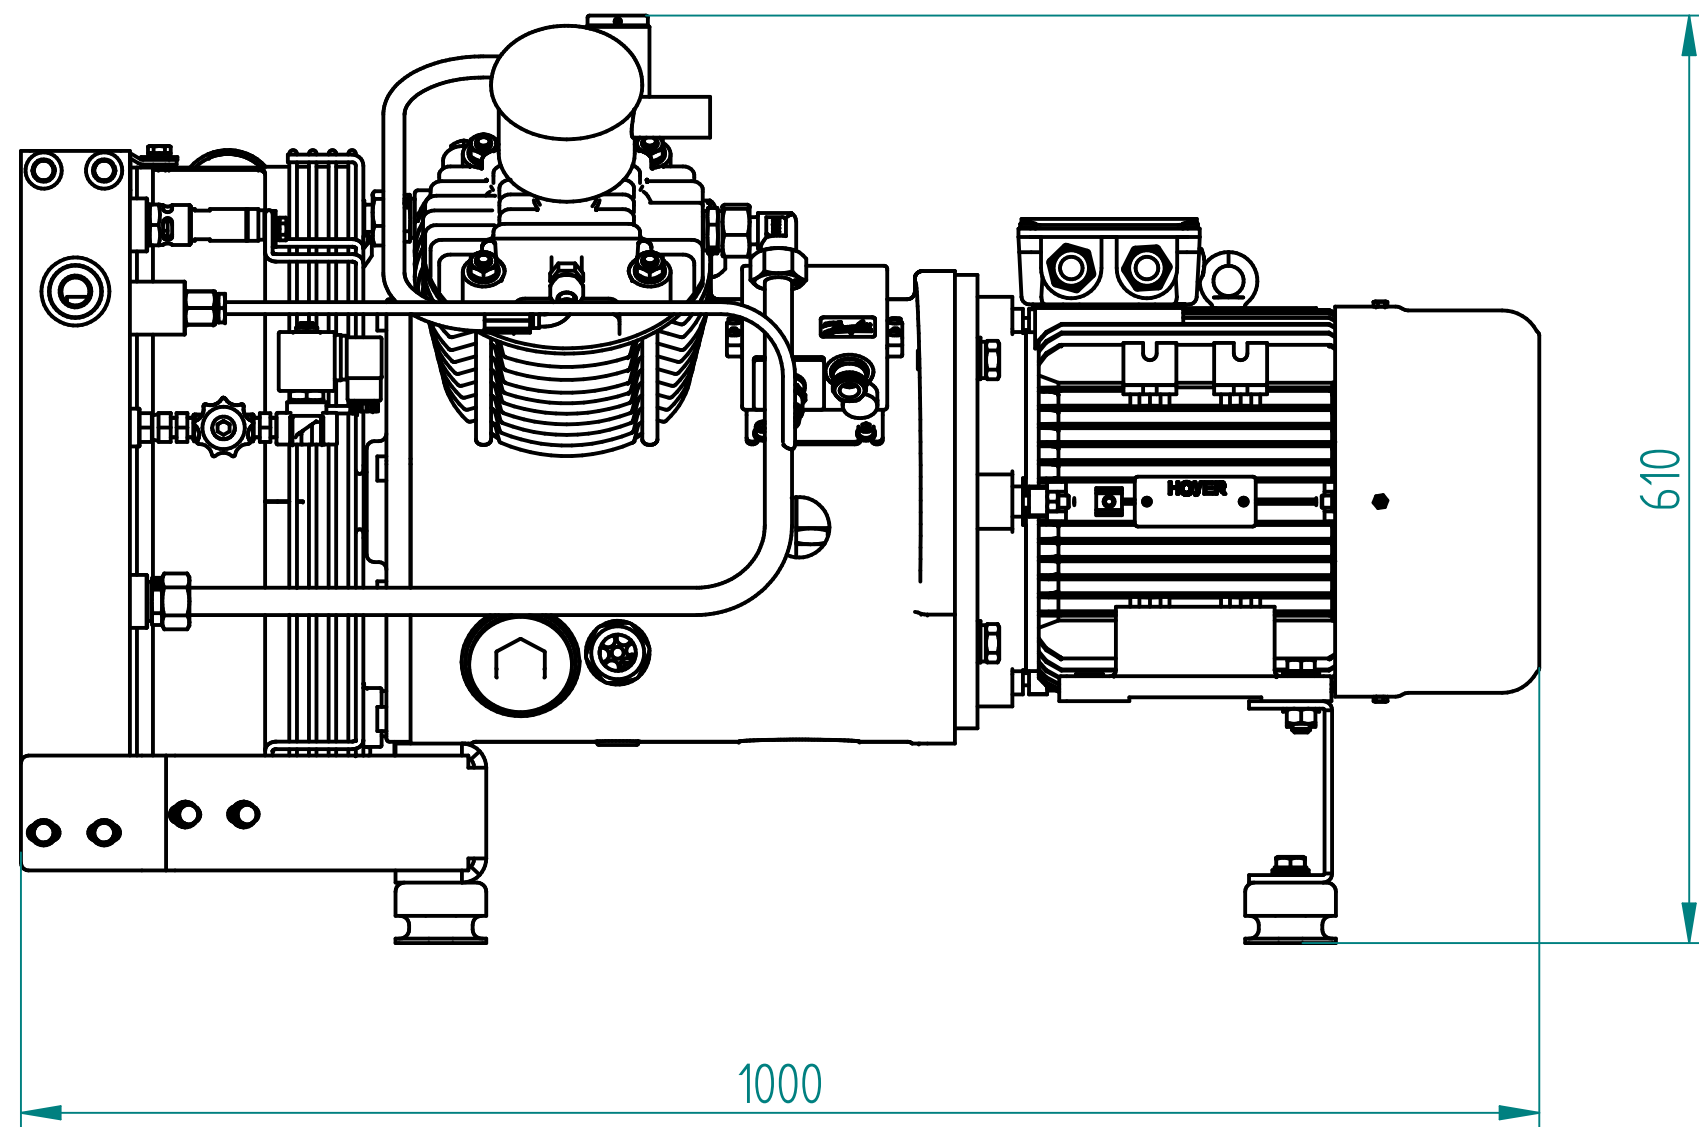



MAIN DIMENSIONS

DRAWN:	NAME:	DATE:
RDK		29/08/19
DRAWING NAME	GA-2L-25-132S-Optional-rev1.dft	
DRAWING TYPE:	GENERAL ARRANGEMENT	

DENO compressors B.V.
www.denocomp.nl
info@denocomp.nl

SCALE: 1:5




SIZE: A2

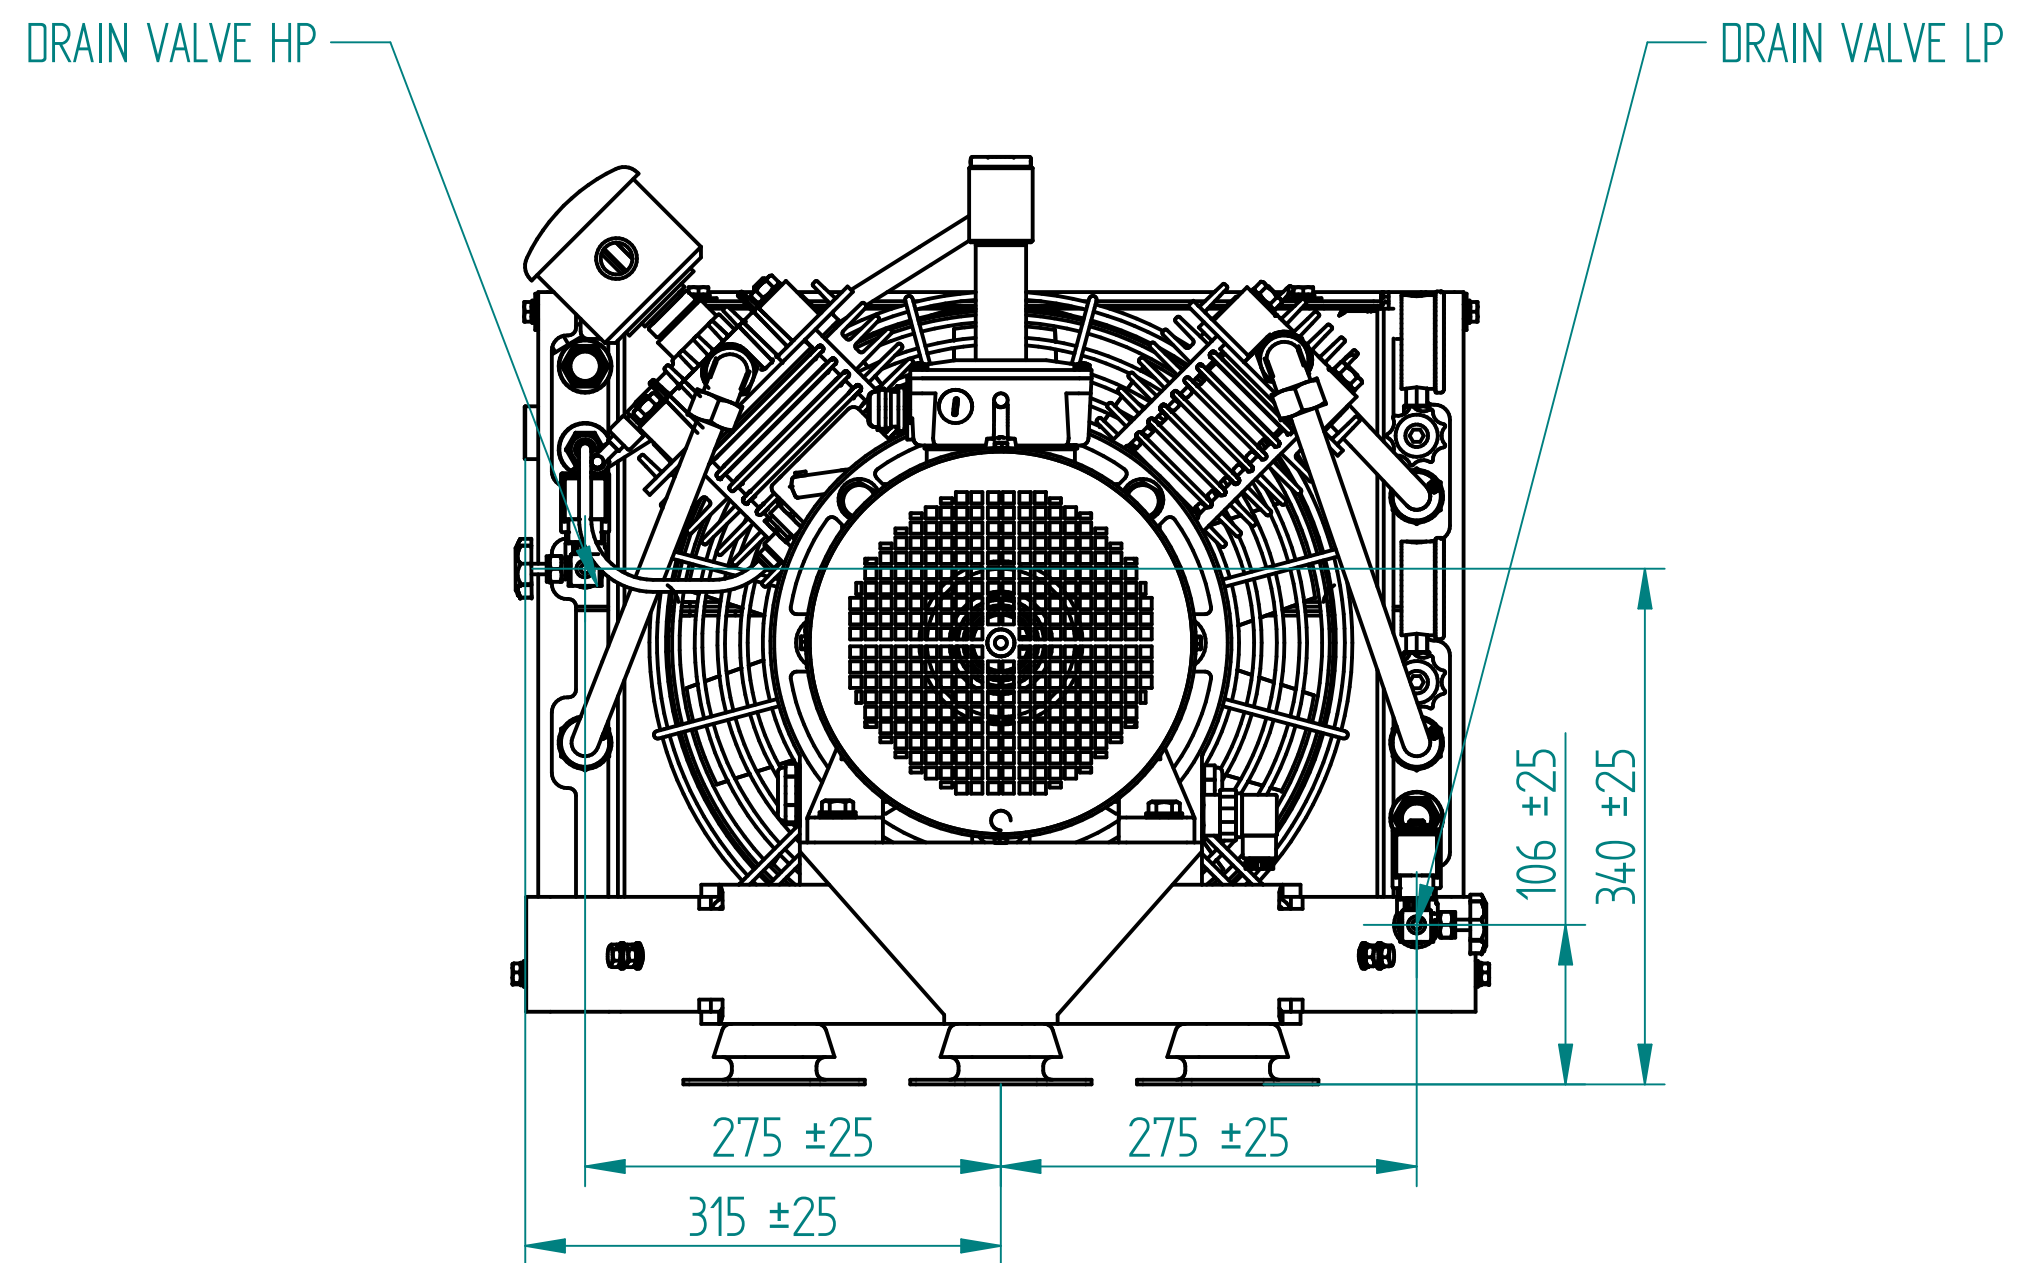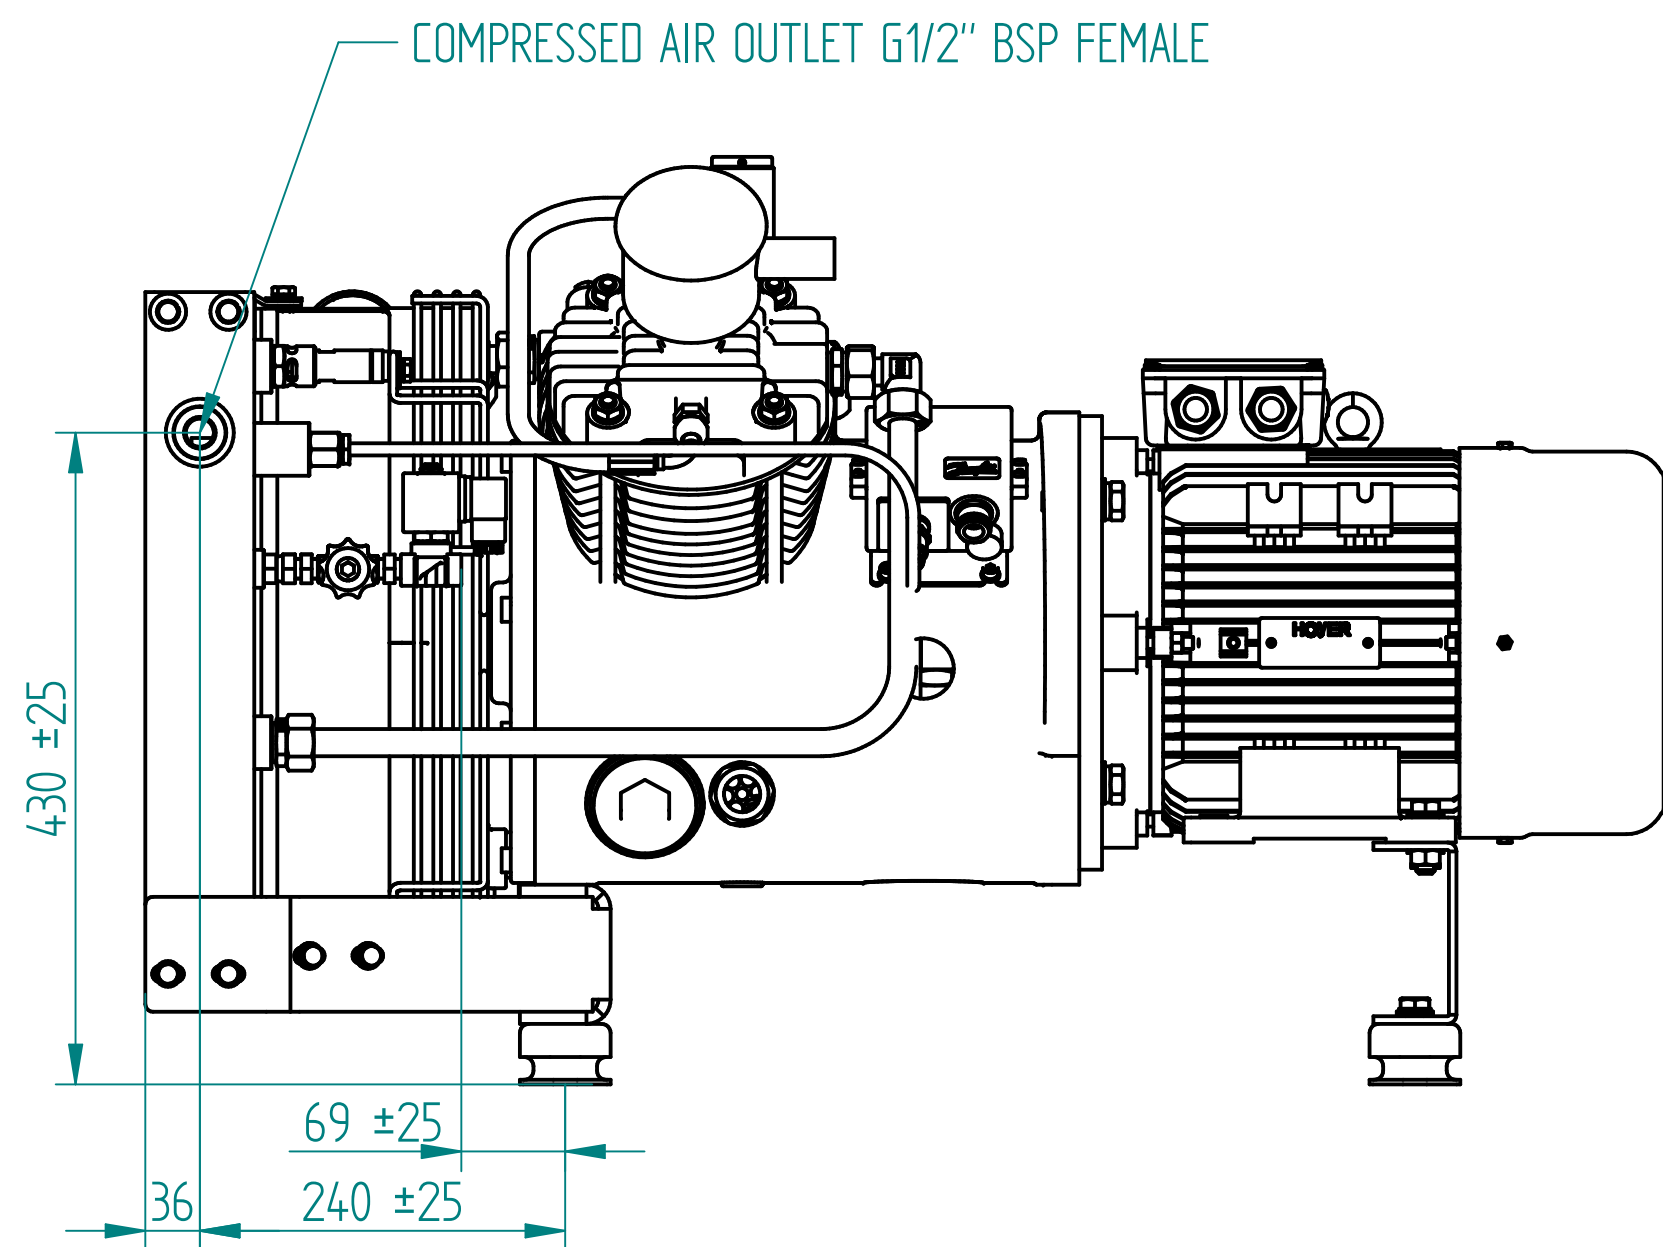

POSITIONS OF CONNECTIONS

DENO compressors B.V. www.denocomp.nl info@denocomp.nl		SCALE: 1:5
SIZE: A2		

NAME:	DATE:
DRAWN: RDK	29/08/19
DRAWING NAME: GA-2L-25-132S-Optional-rev1.dft	
DRAWING TYPE: GENERAL ARRANGEMENT	

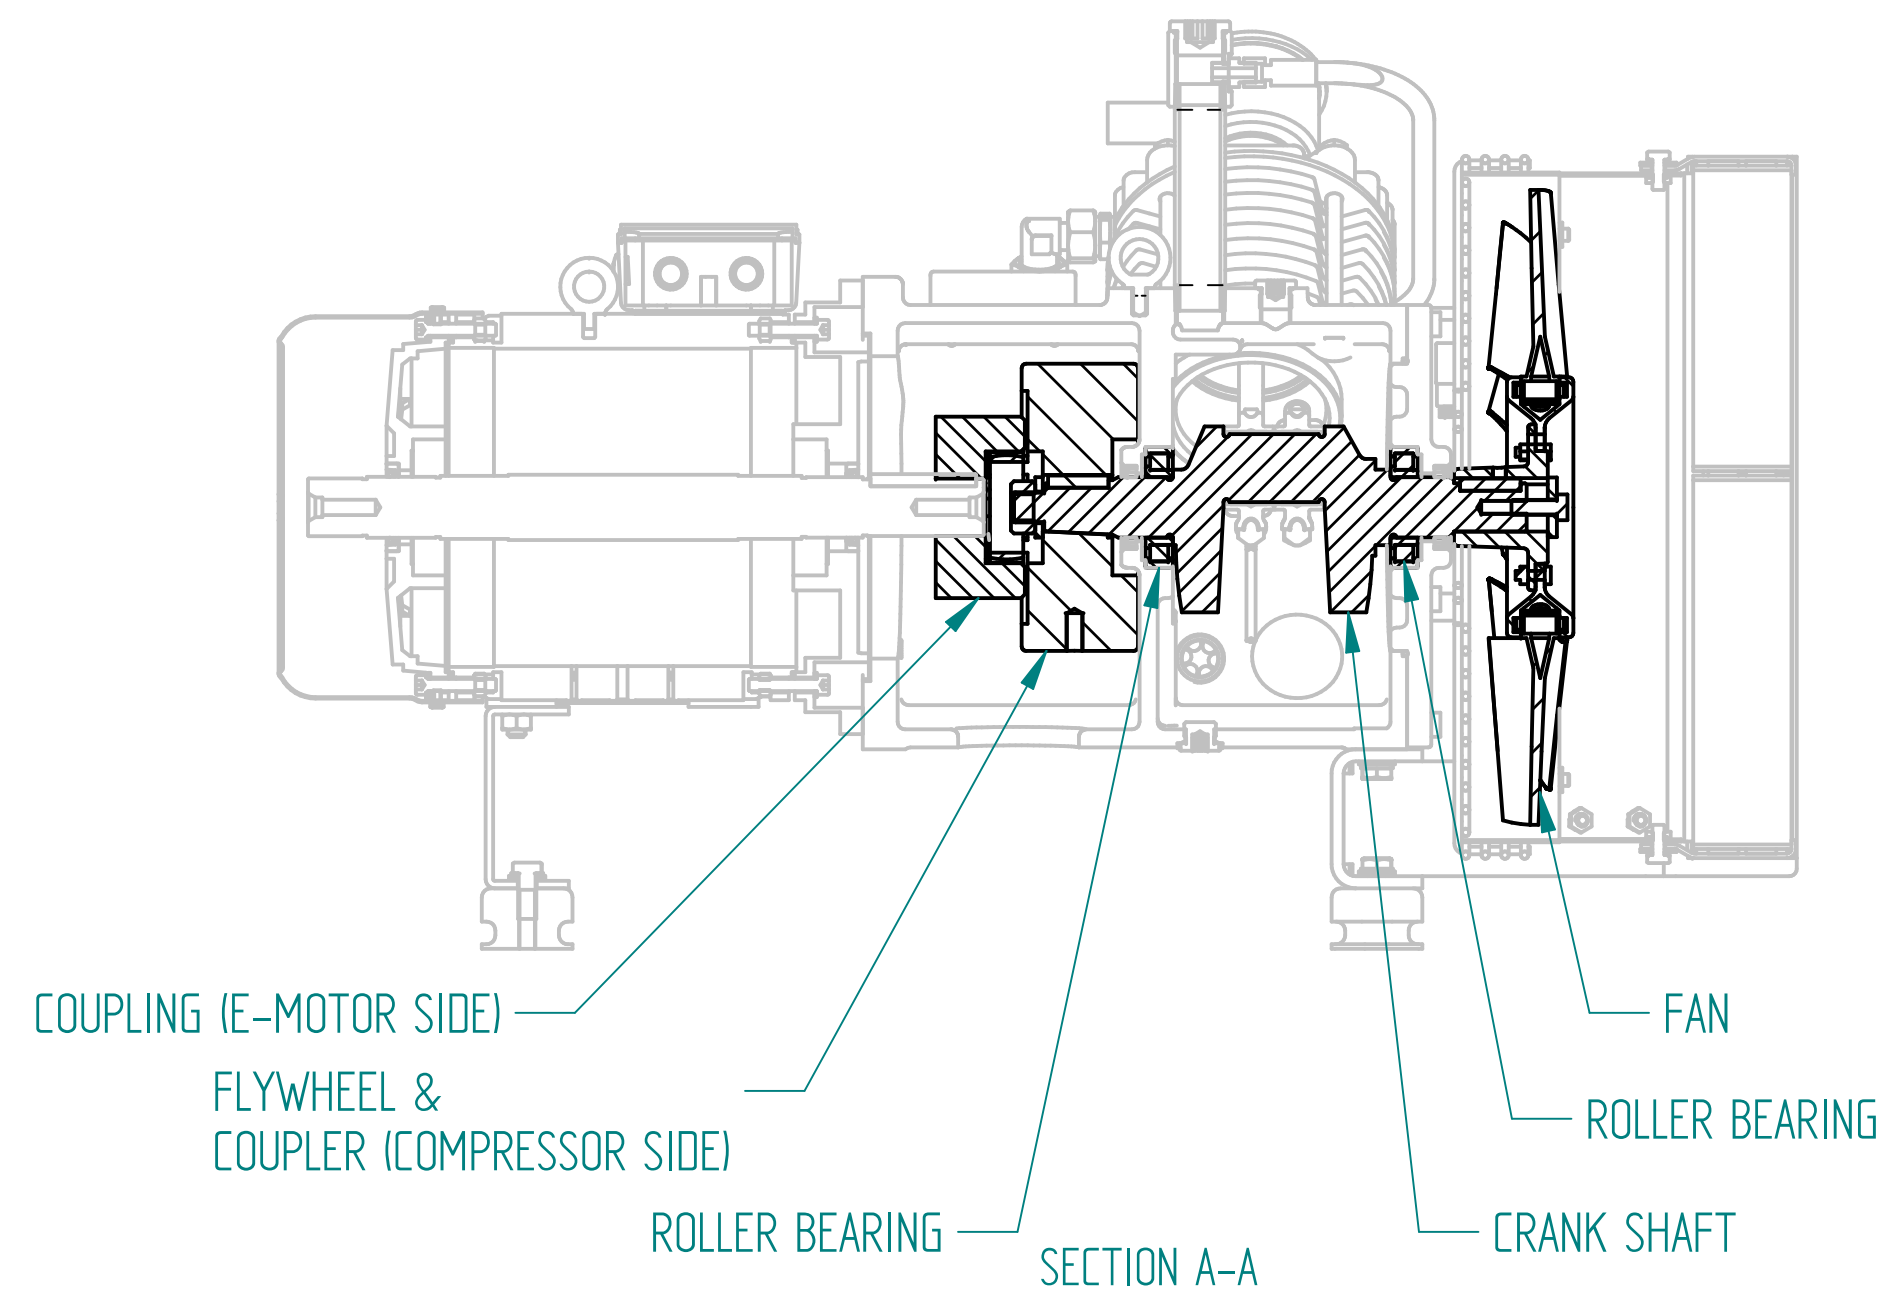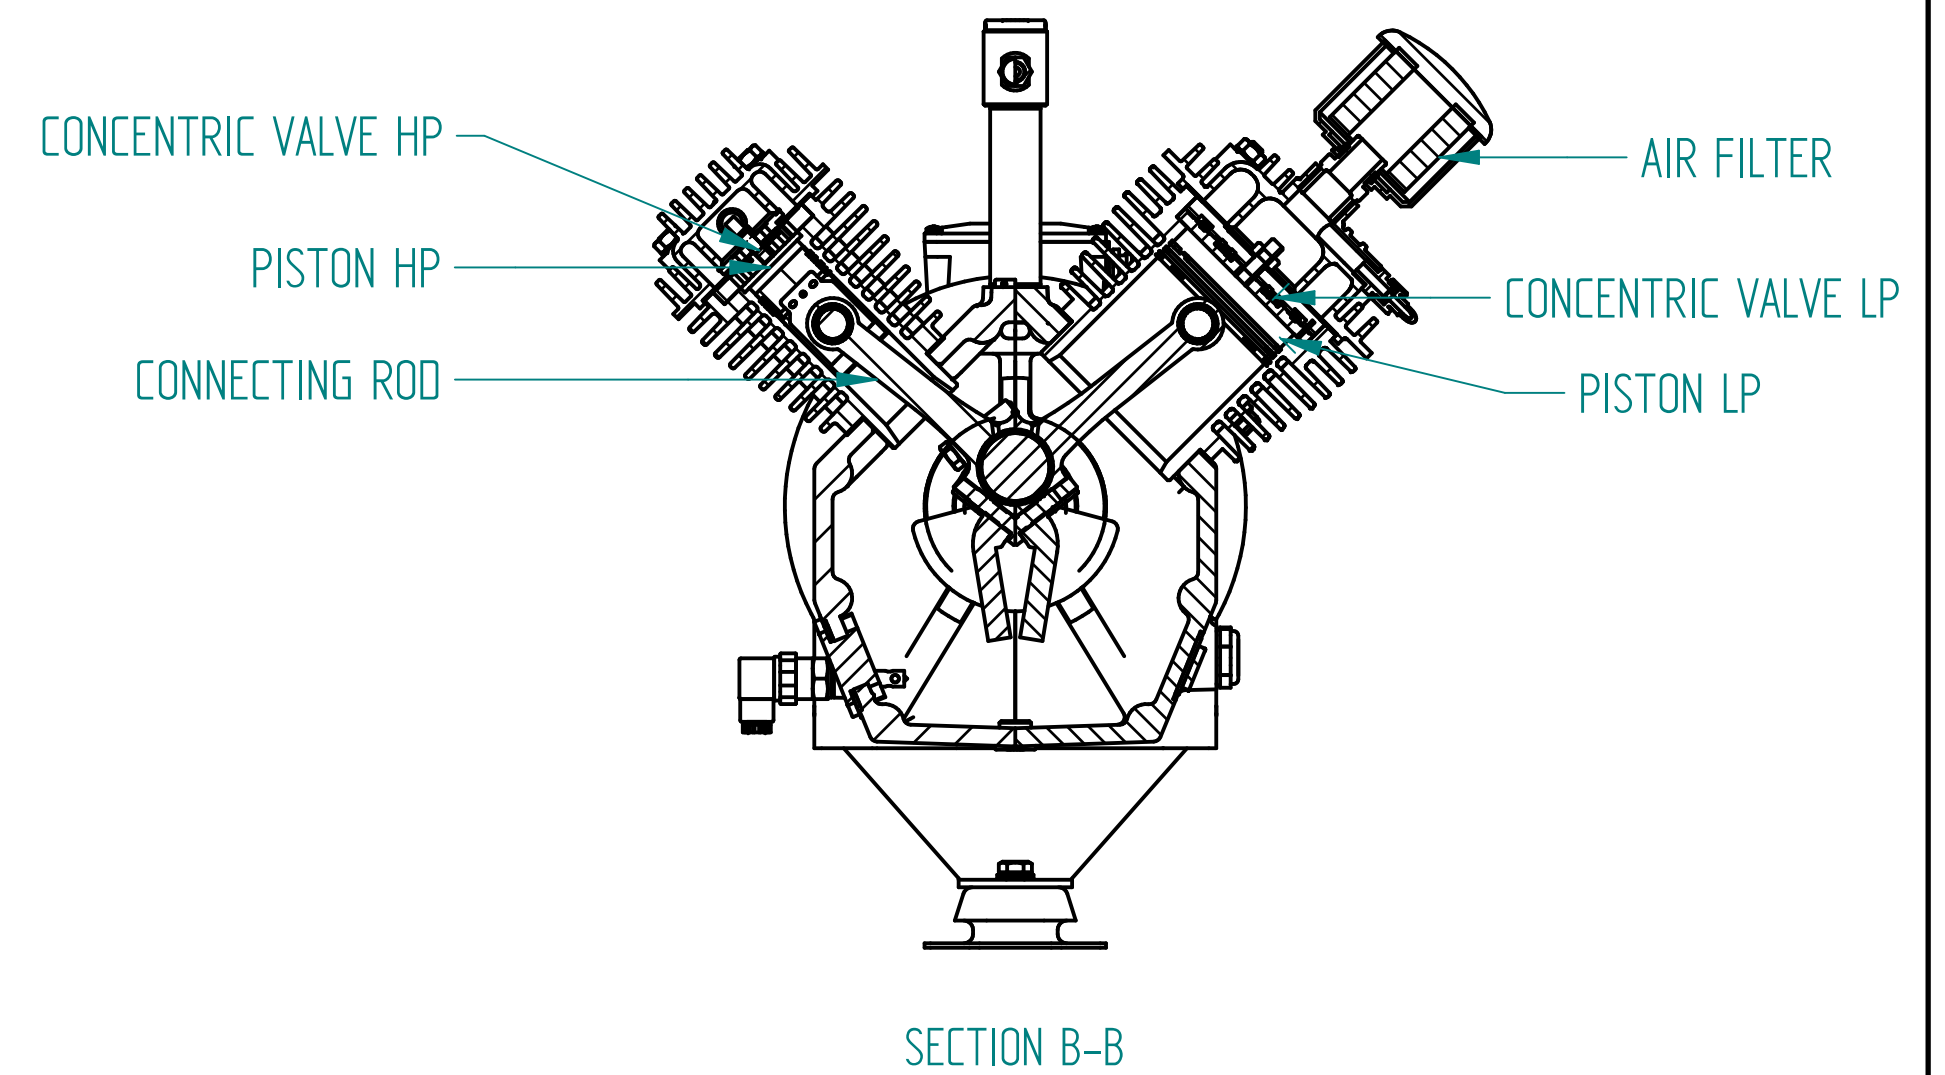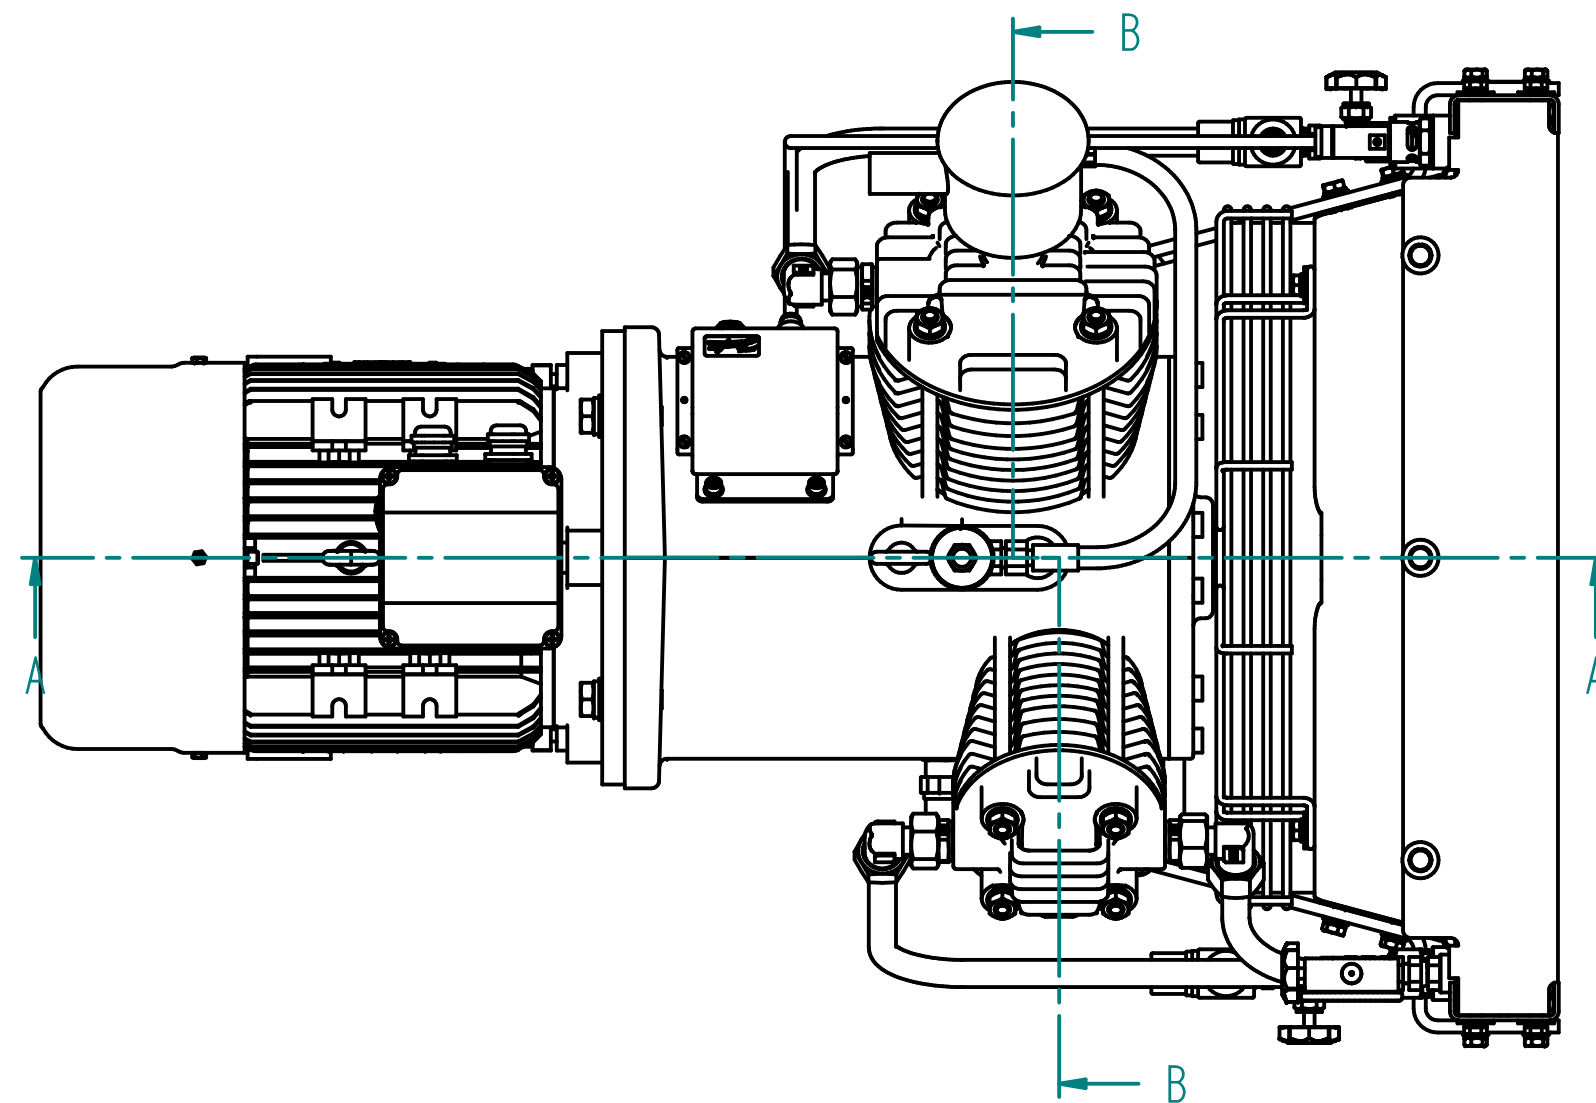

	NAME:	DATE:
DRAWN:	RDK	29/08/19
DRAWING NAME:	GA-2L-25-132S-Optional-rev1.dft	
DRAWING TYPE:	GENERAL ARRANGEMENT	




SECTION VIEWS

DENO compressors B.V.
www.denocomp.nl
info@denocomp.nl

SCALE: 1:5

SIZE: A2

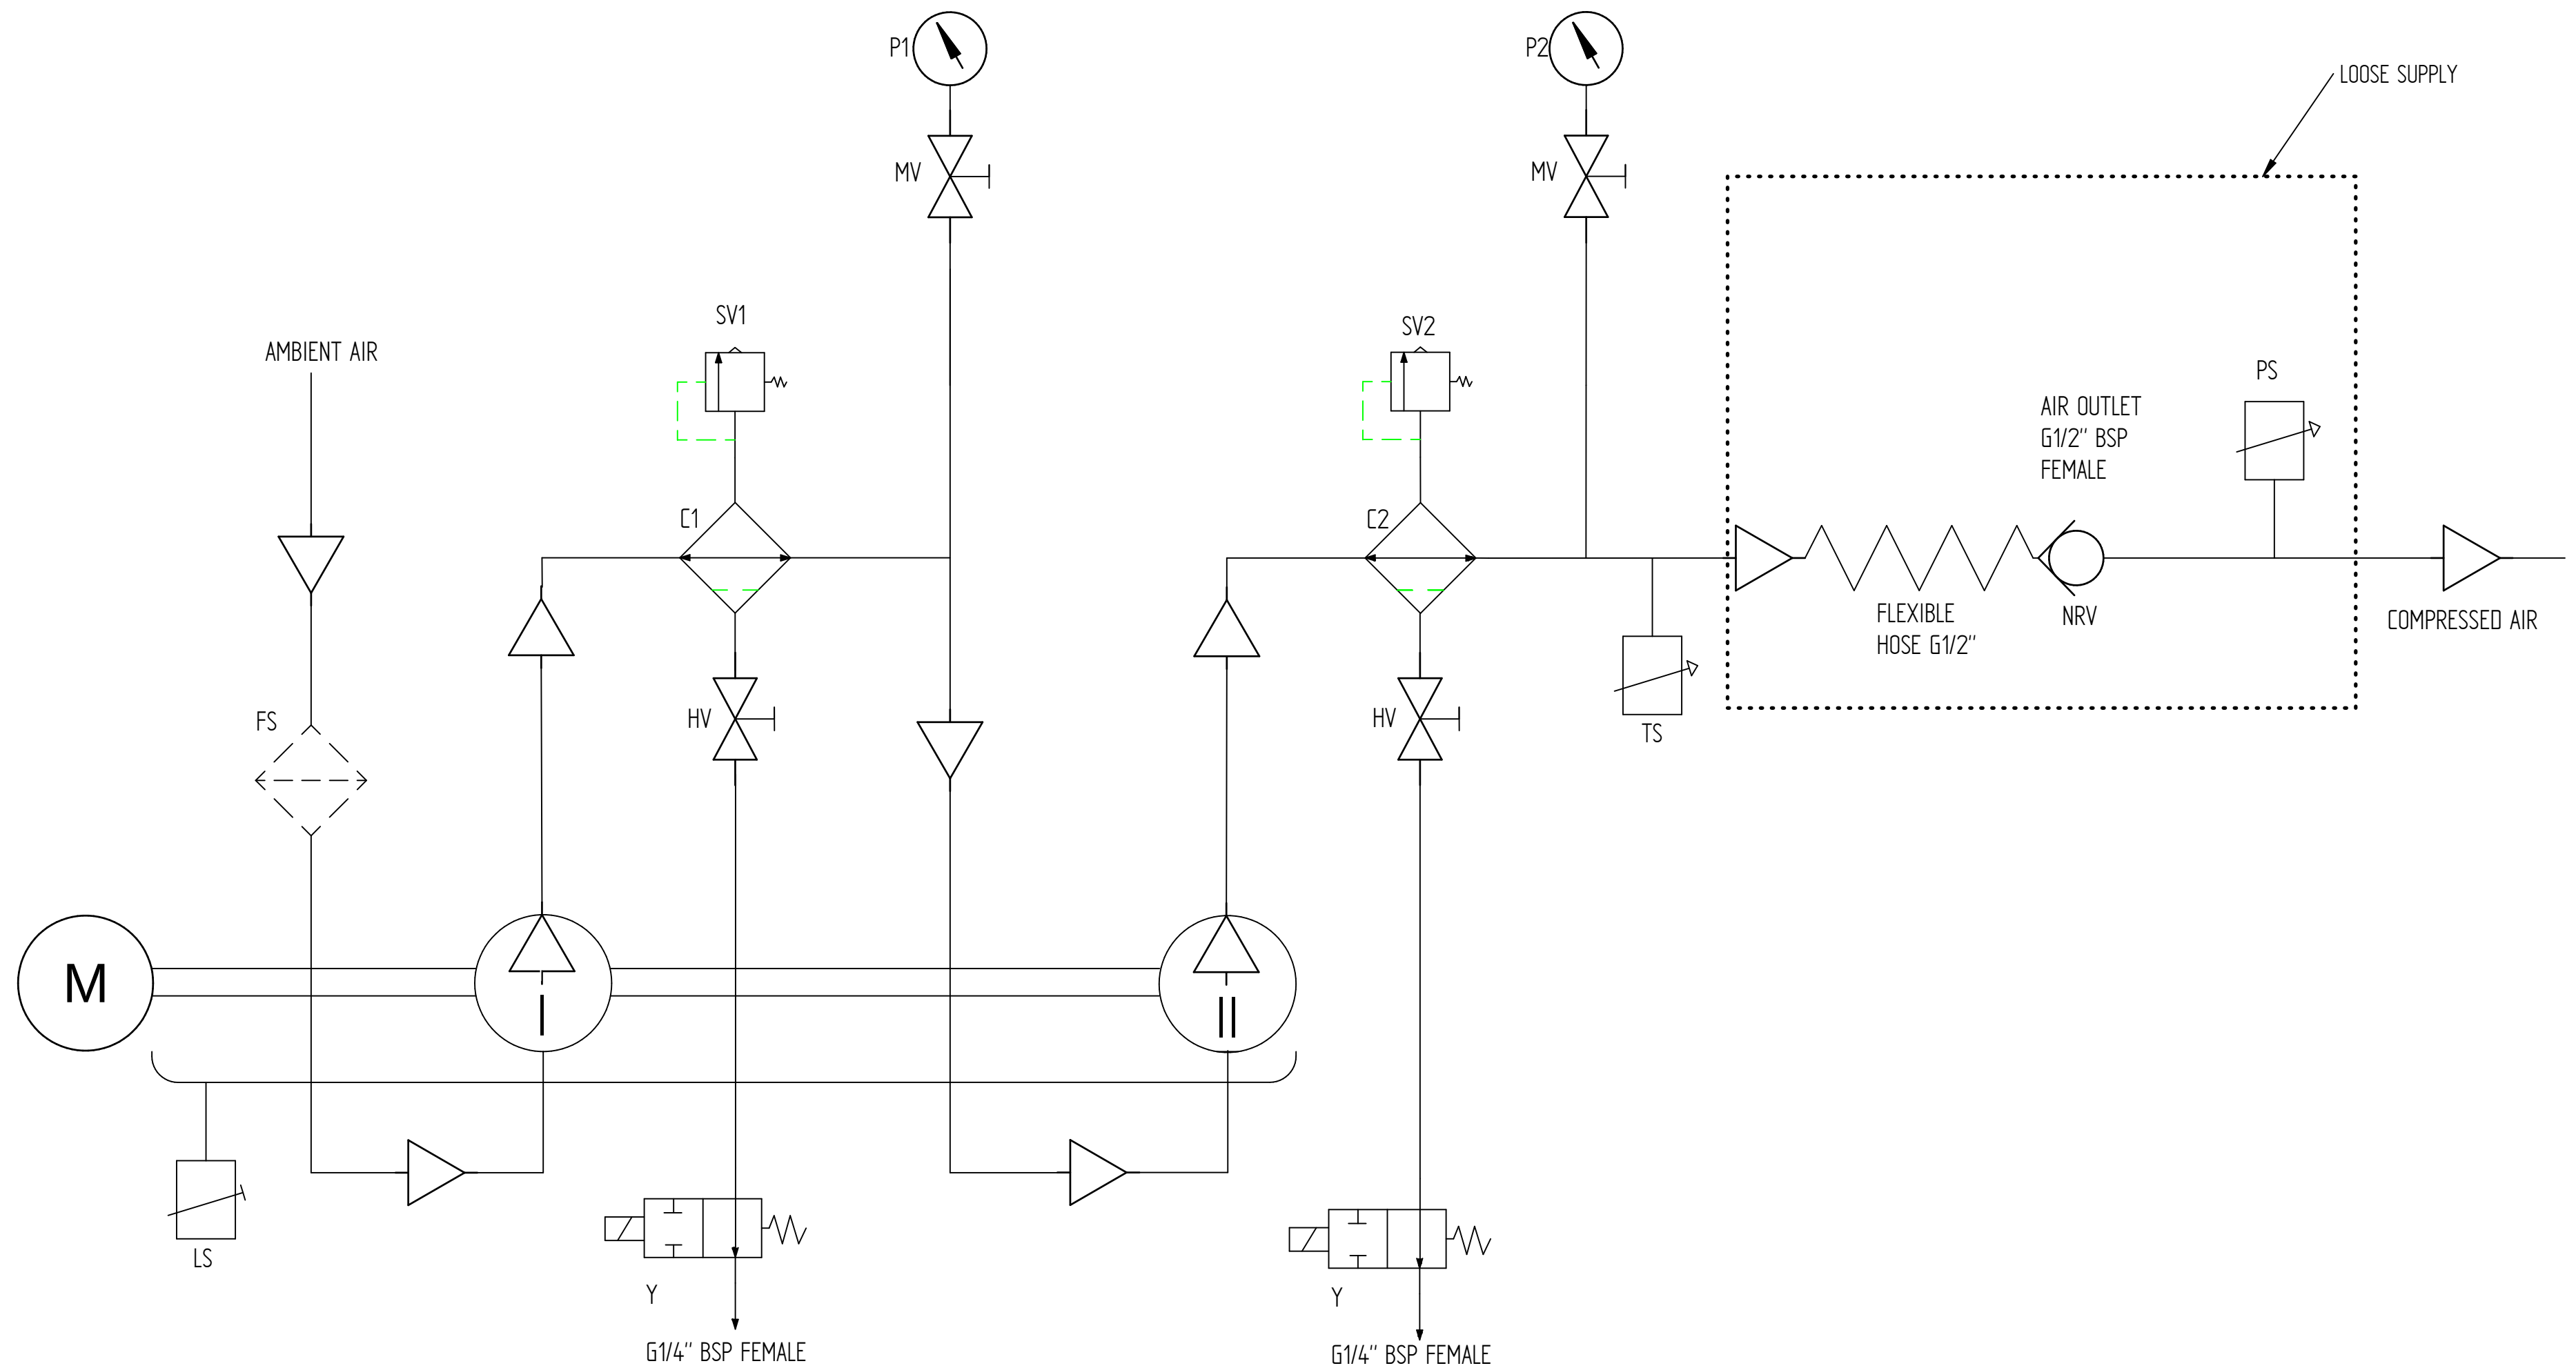

LEGEND P&I DIAGRAM:

FS	FILTER & SILENCER	Y	UNLOADING-DRAIN SOLENOID VALVE
M	E-MOTOR	NRV	NON -RETURN VALVE
I	COMPRESSOR STAGE 1	MV	MANUAL VALVE
II	COMPRESSOR STAGE 2	HV	MANUAL DRAIN VALVE
C1	INTER COOLER WITH INTEGRATED OIL-WATER SEPARATOR	PS	PRESSURE SWITCH
C2	AFTER COOLER WITH INTEGRATED OIL-WATER SEPARATOR	TS	TEMPERATURE SWITCH
SV1	SAFETY VALVE STAGE 1	LS	OIL LEVEL SENSOR
SV2	SAFETY VALVE STAGE 2		
P1	PRESSURE GAUGE STAGE 1		
P2	PRESSURE GAUGE STAGE 2		



P&ID - 2L-Series

	NAME:	DATE:
DRAWN:	RDK	29/08/19
DRAWING NAME	GA-2L-25-132S-Optional-rev1.dft	
DRAWING TYPE:	GENERAL ARRANGEMENT	

DENO compressors B.V.
www.denocomp.nl
info@denocomp.nl

SCALE: 1:1
SIZE: A2