


# General Arrangement 3LS Series

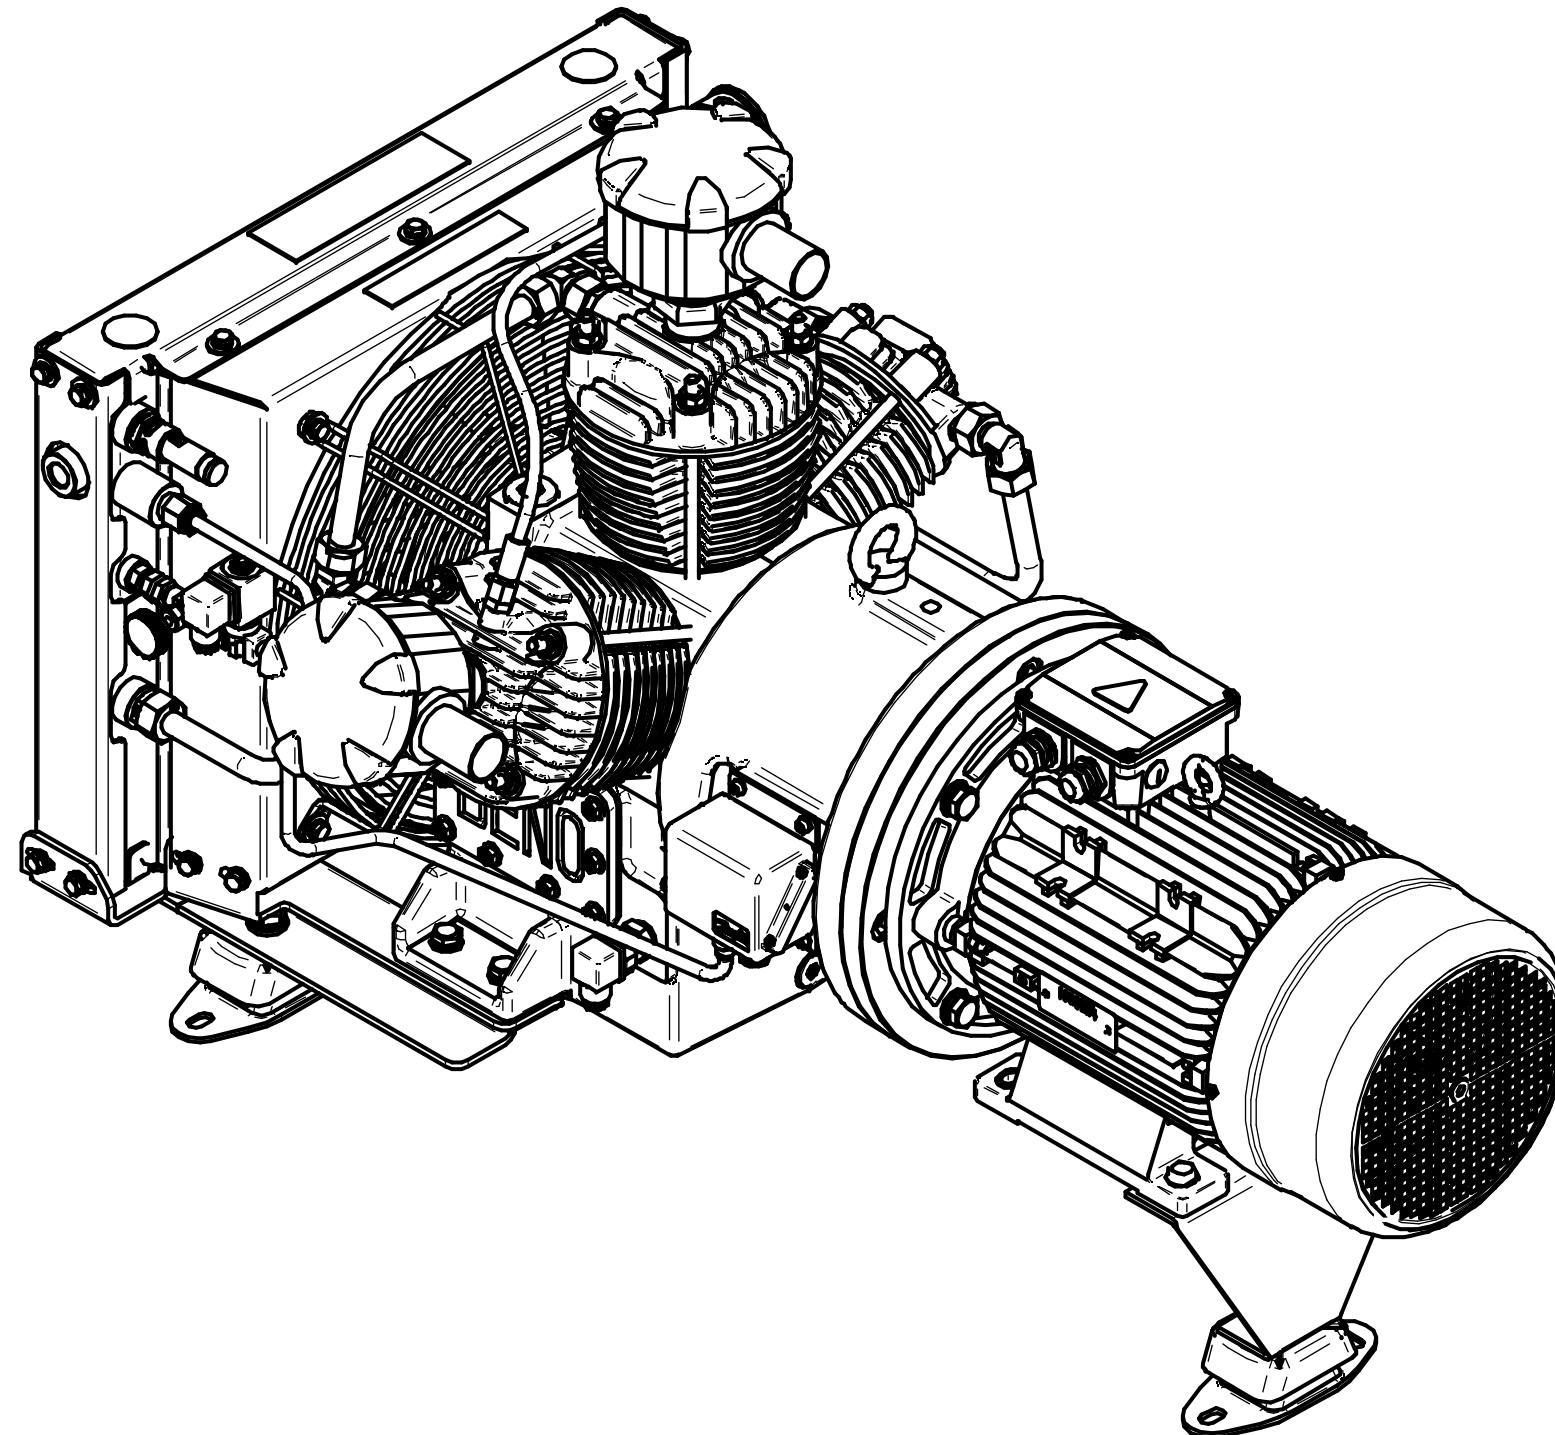

3L-42 132M

	NAME:	DATE:
DRAWN:	EL	12/11/21
DRAWING TYPE:	General Arrangement	
DOCUMENT:	GA-3L-42-132M-Full Option.dft	

DENO compressors B.V.  
www.denocomp.nl  
info@denocomp.nl

SCALE: 1:10  
SIZE: A3



Read the manual  
Before first Start-Up

- Warning signs;
- Rotating Parts
  - Danger of crushing
  - High Surface temperature
  - Automatic Start/Stop
  - Pressurized Air


Loud Noises  
Wear Ear protection

Direction of Rotation

Caution of High voltage

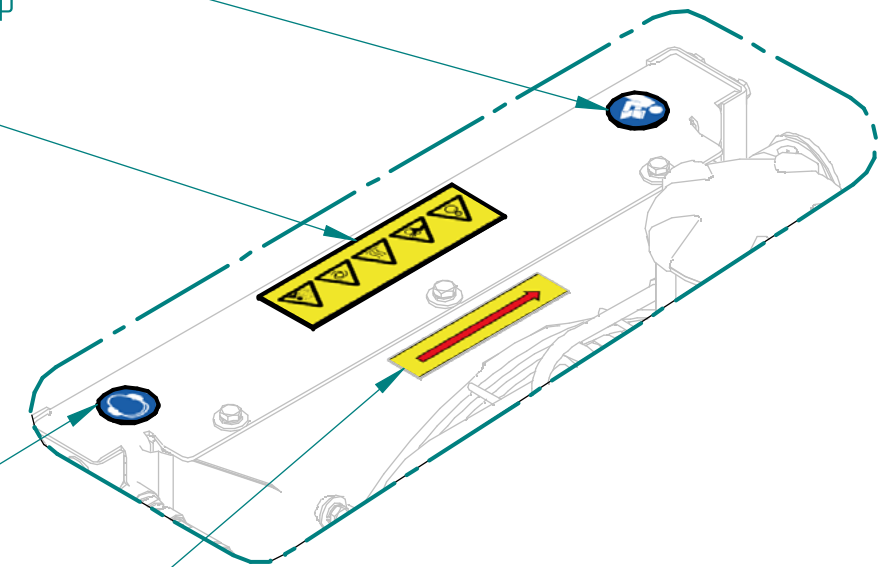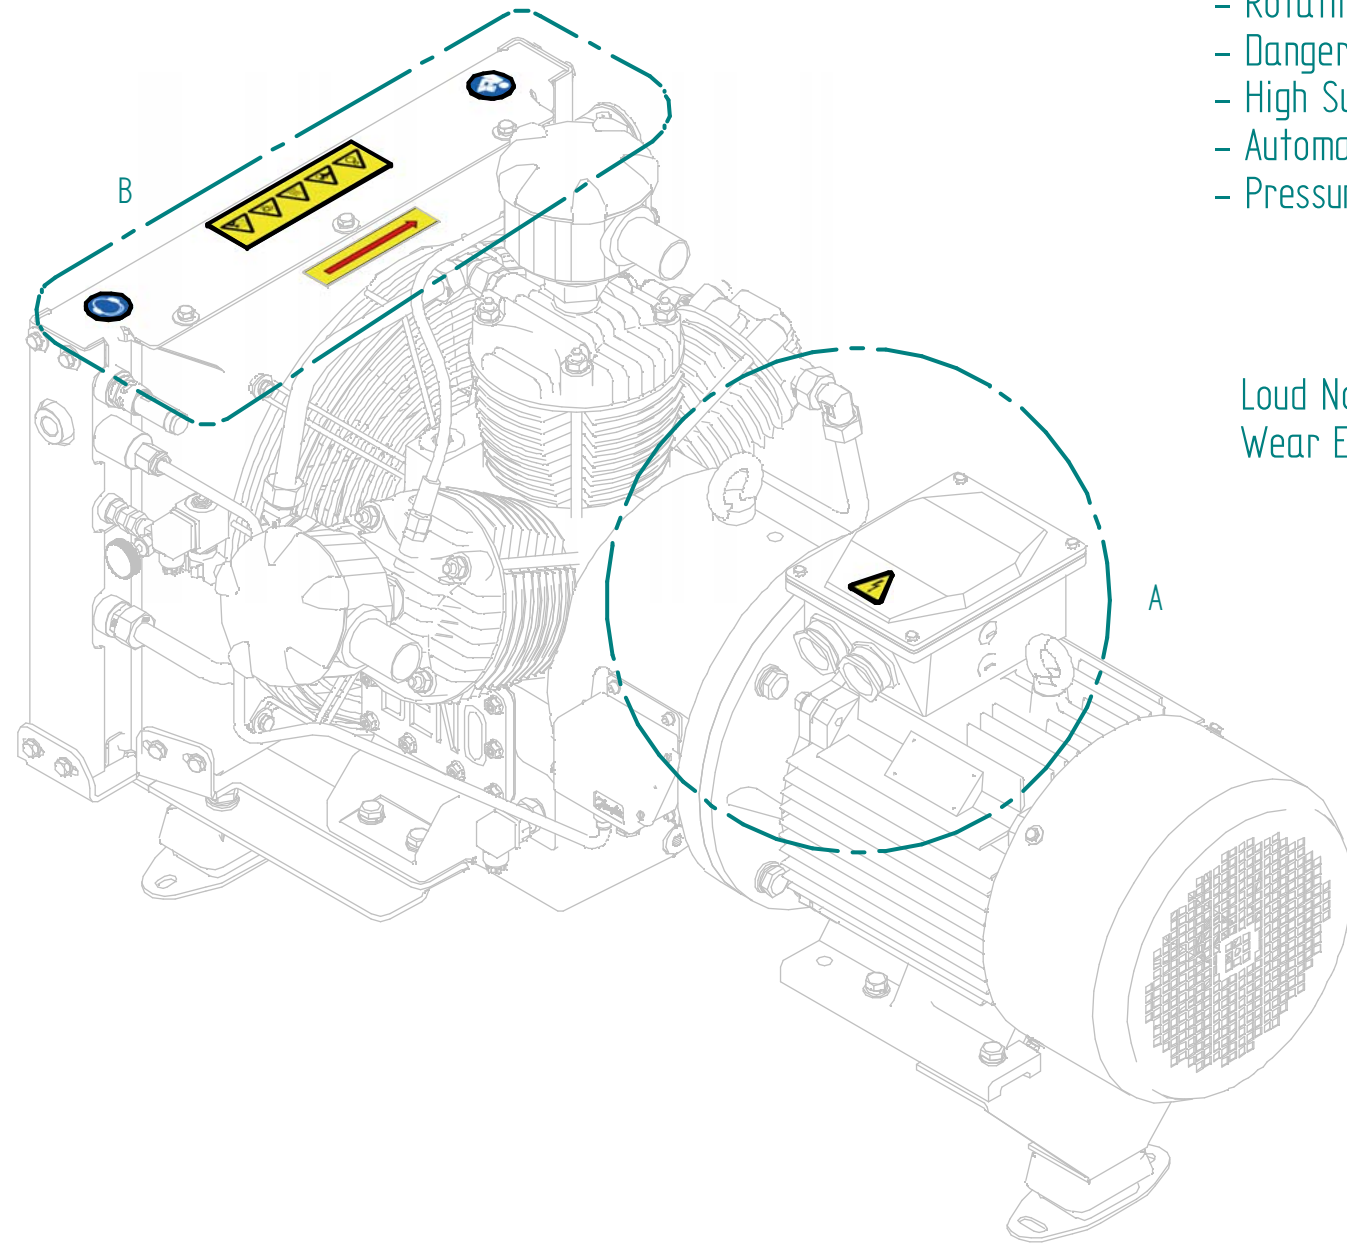

DETAIL B

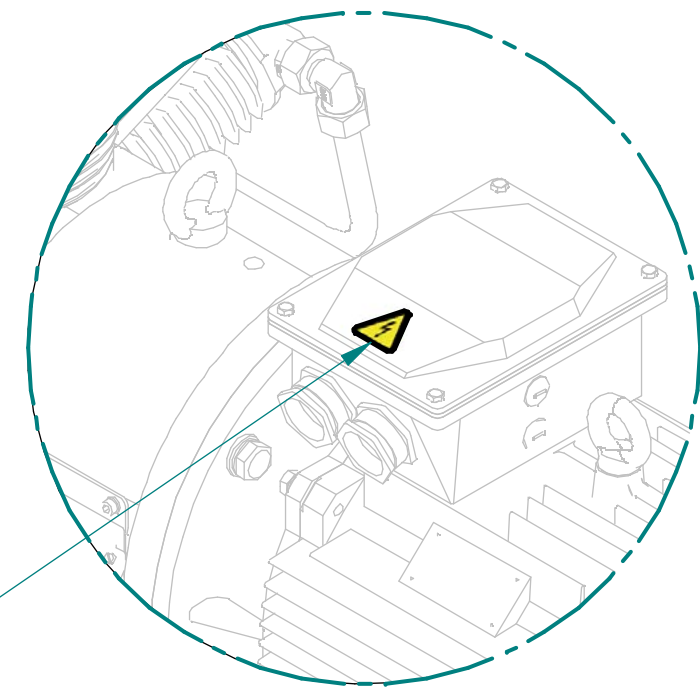

DETAIL A




## Safety Warnings

	NAME:	DATE:
DRAWN:	EL	12/11/21
DRAWING TYPE:	General Arrangement	
DOCUMENT:	GA-3L-42-132M-Full Option.dft	

DENO compressors B.V.  
www.denocomp.nl  
info@denocomp.nl

SCALE: 1:10

SIZE: A3

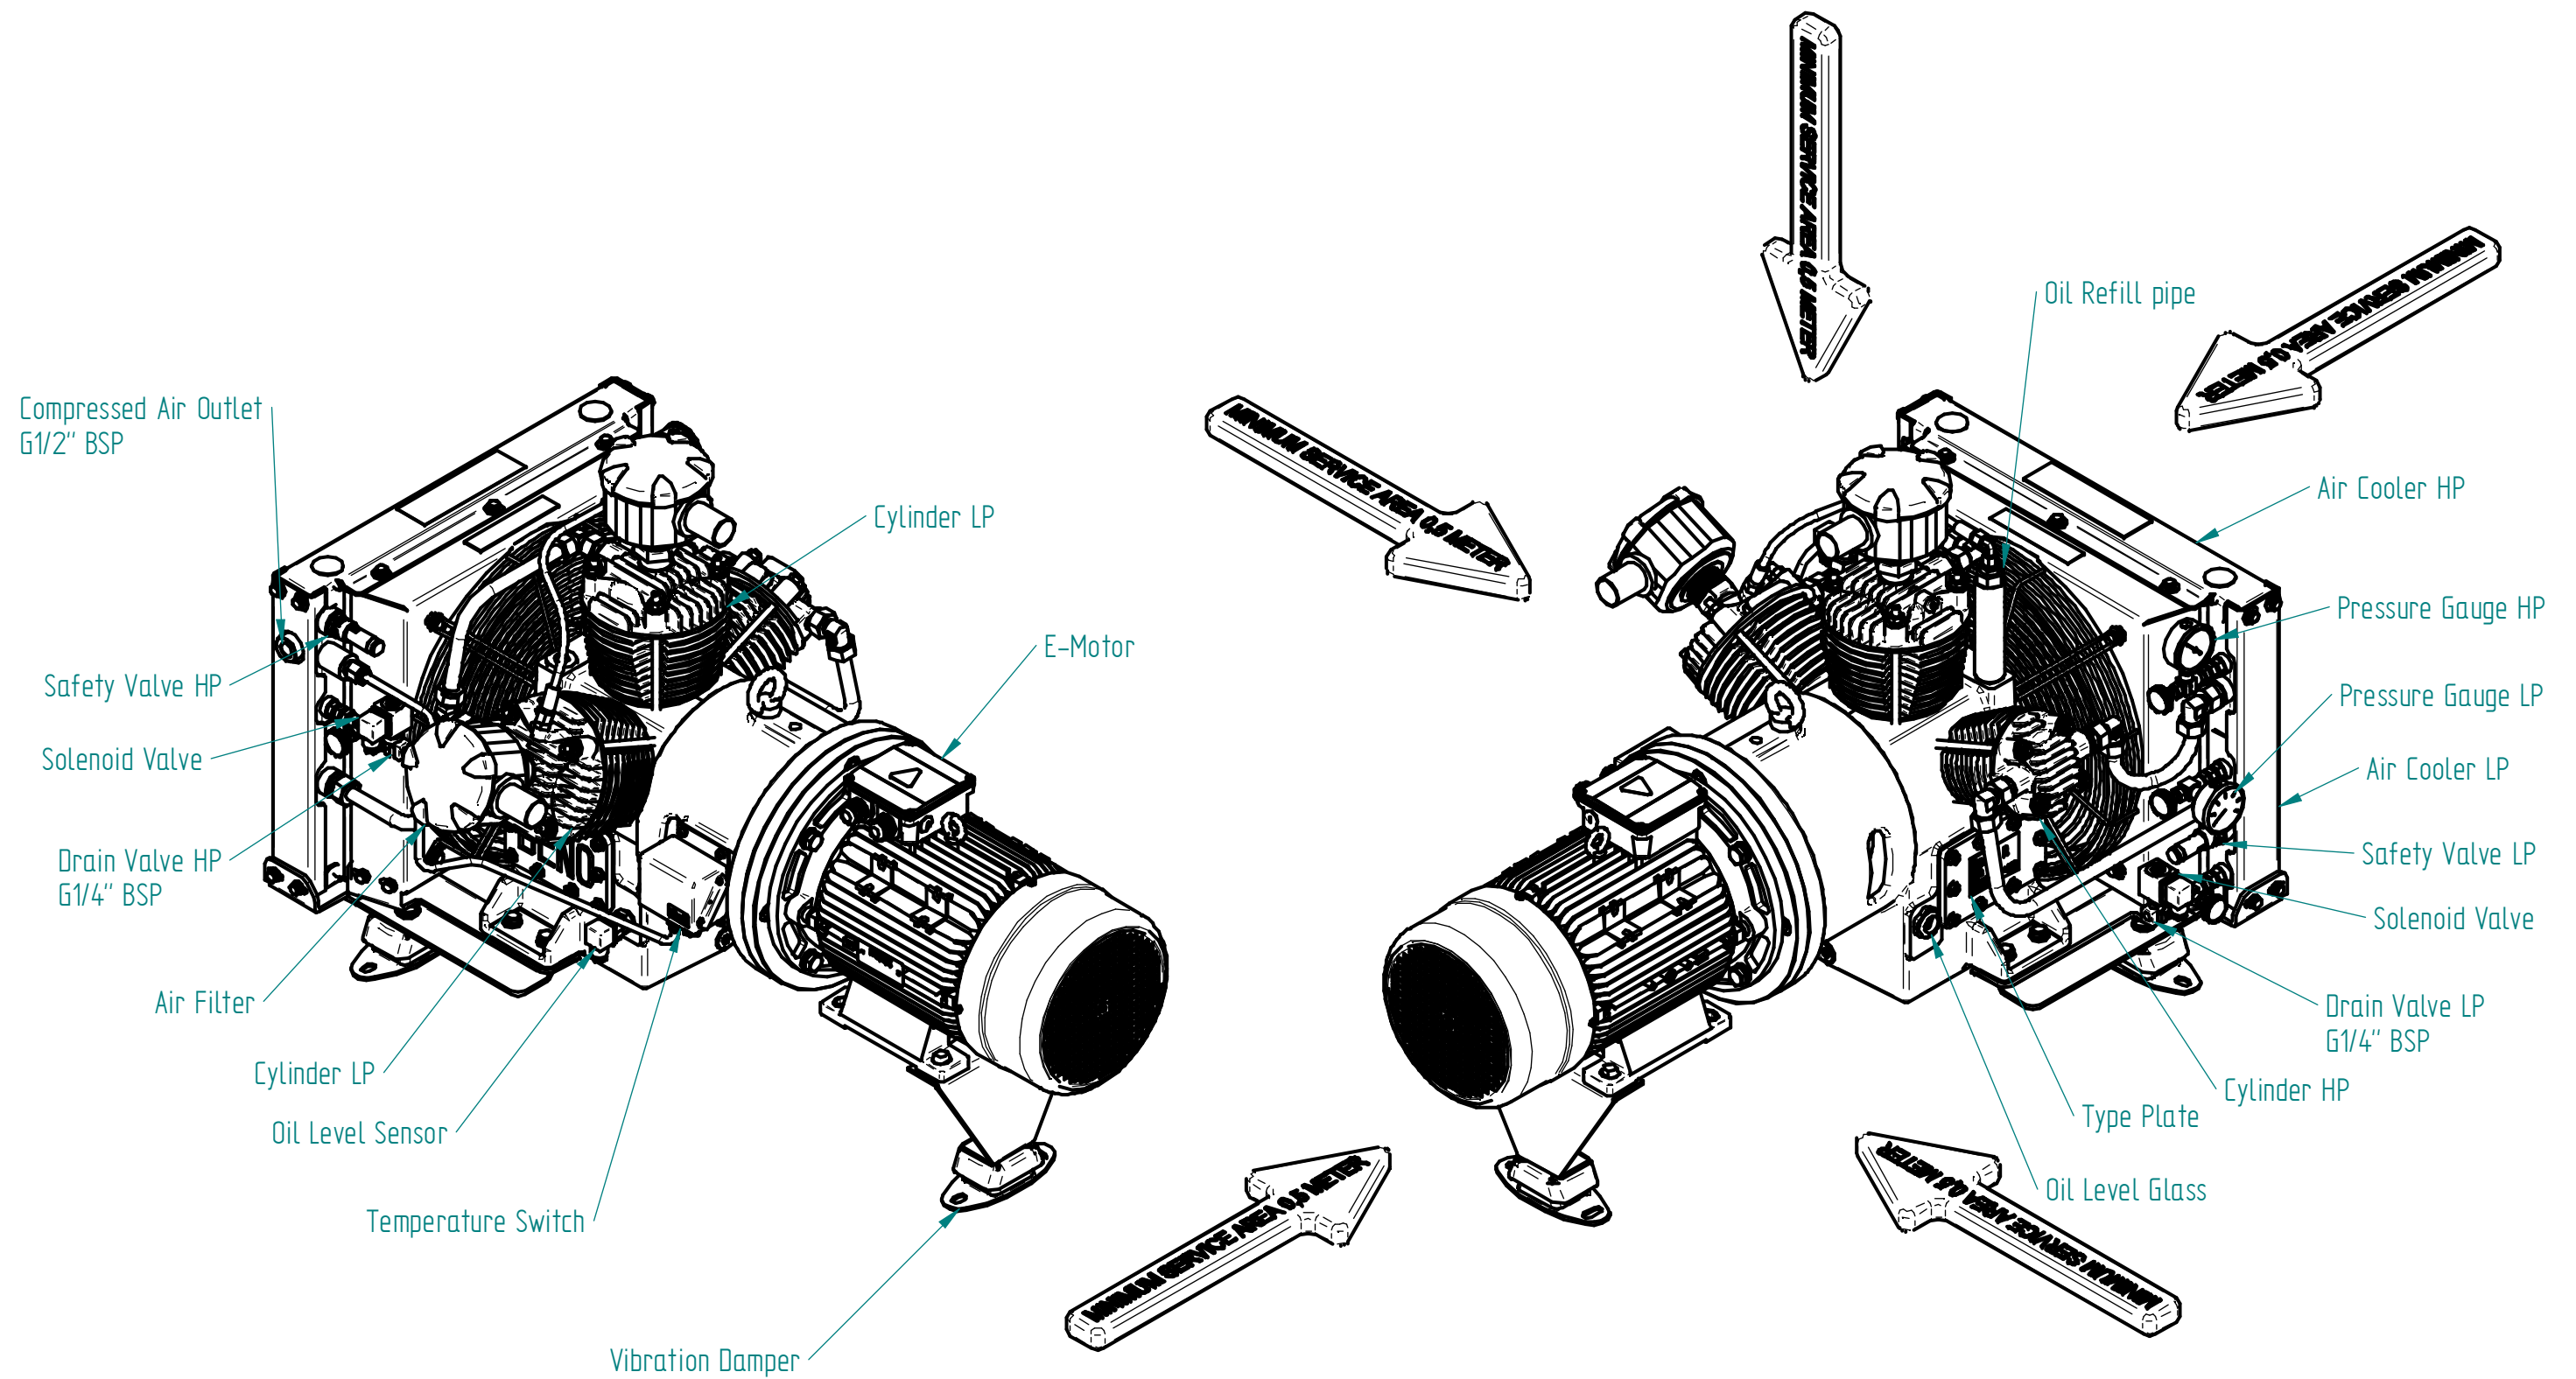




## Names of Outside Parts

	NAME:	DATE:
DRAWN:	EL	12/11/21
DRAWING TYPE:	General Arrangement	
DOCUMENT:	GA-3L-42-132M-Full Option.dft	

DENO compressors B.V.  
www.denocomp.nl  
info@denocomp.nl

SCALE: 1:10

SIZE: A3

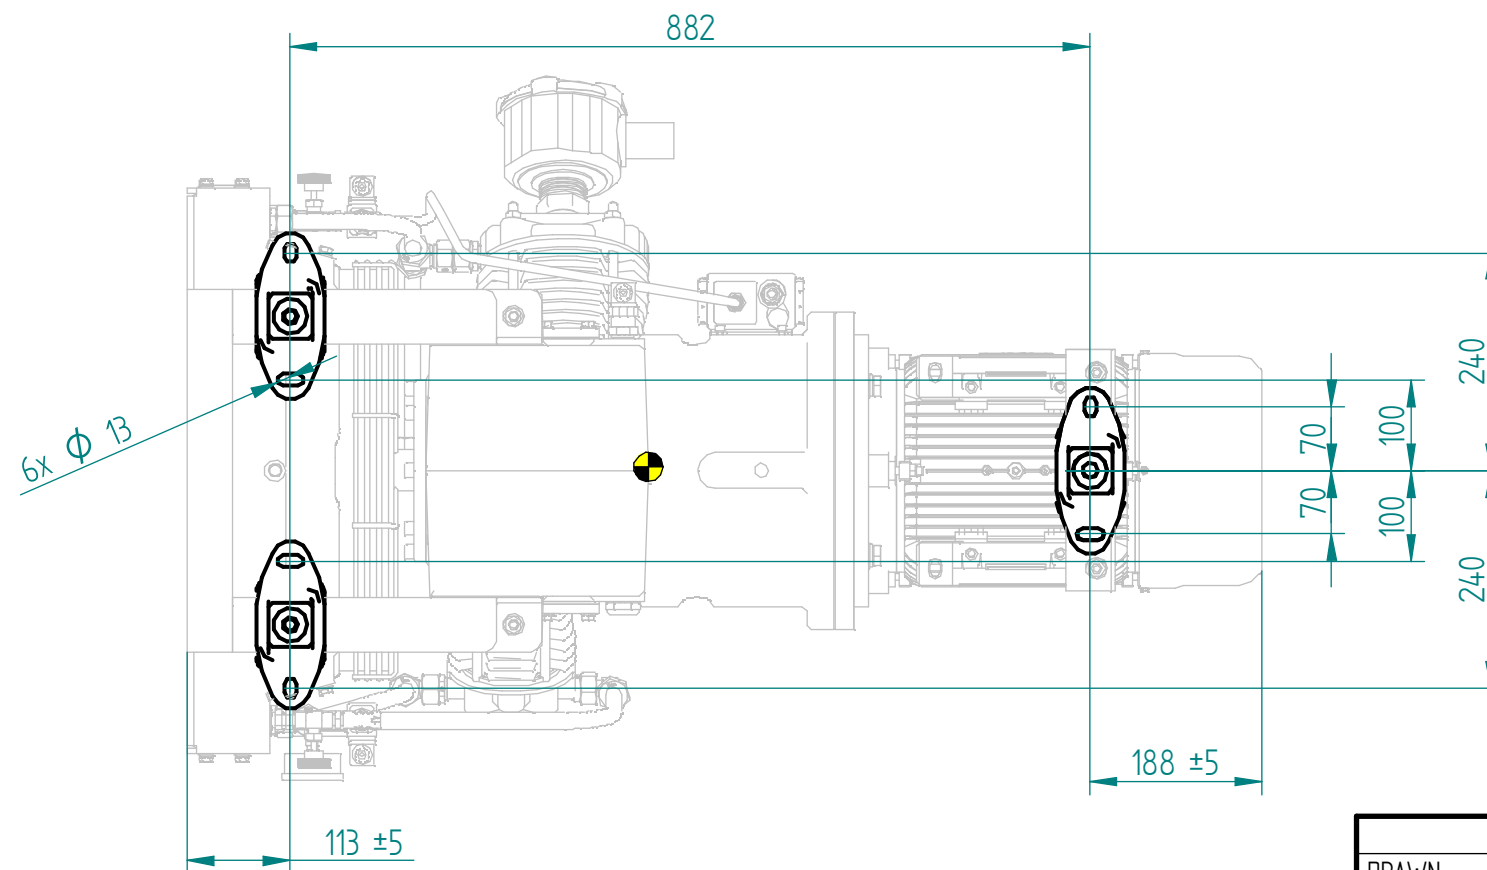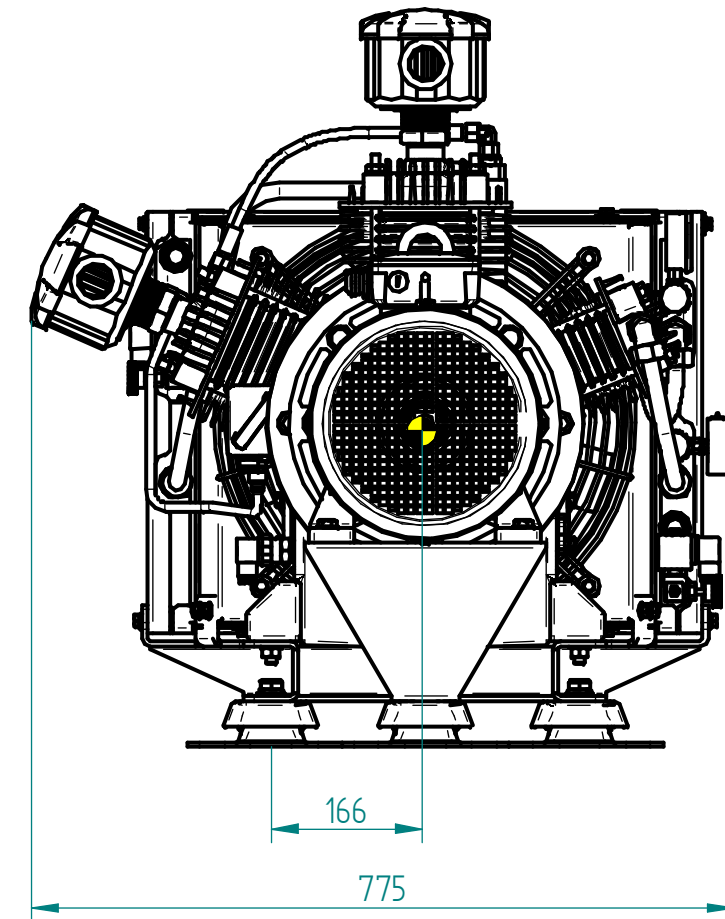
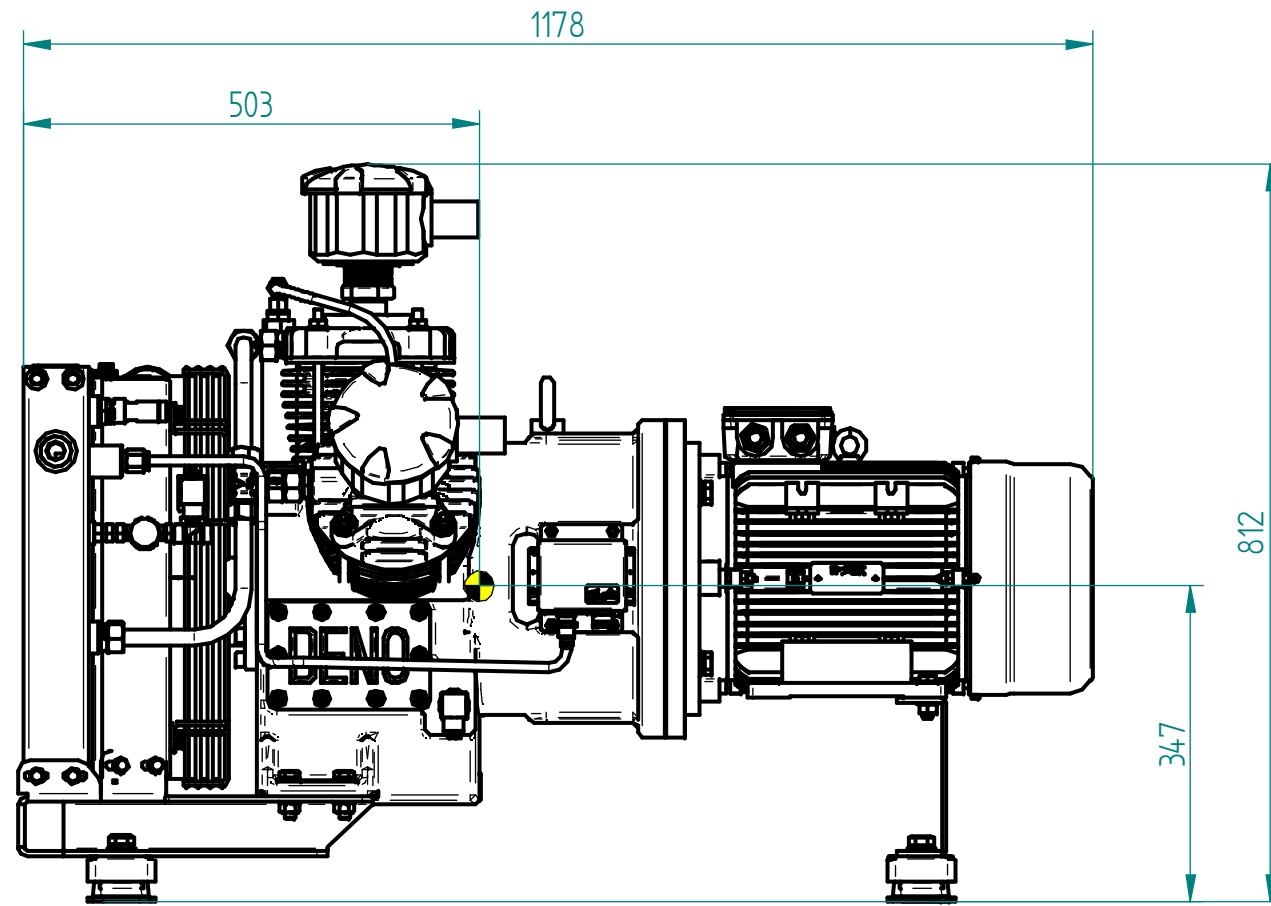


### Main Dimensions

NAME:	DATE:
DRAWN: EL	12/11/21
DRAWING TYPE: General Arrangement	
DOCUMENT: GA-3L-42-132M-Full Option.dft	

DENO compressors B.V.  
 www.denocomp.nl  
 info@denocomp.nl

SCALE: 1:10  
 SIZE: A3

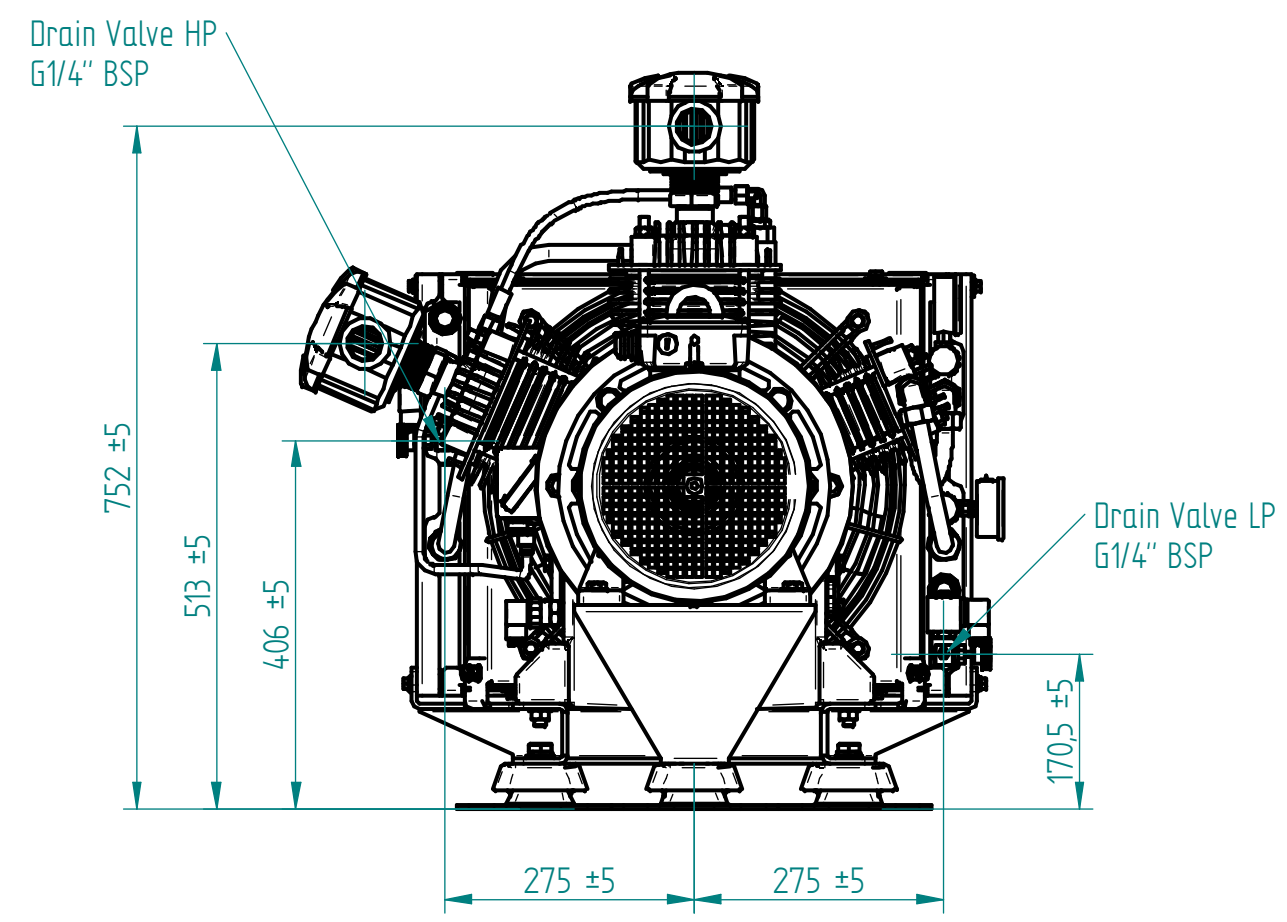
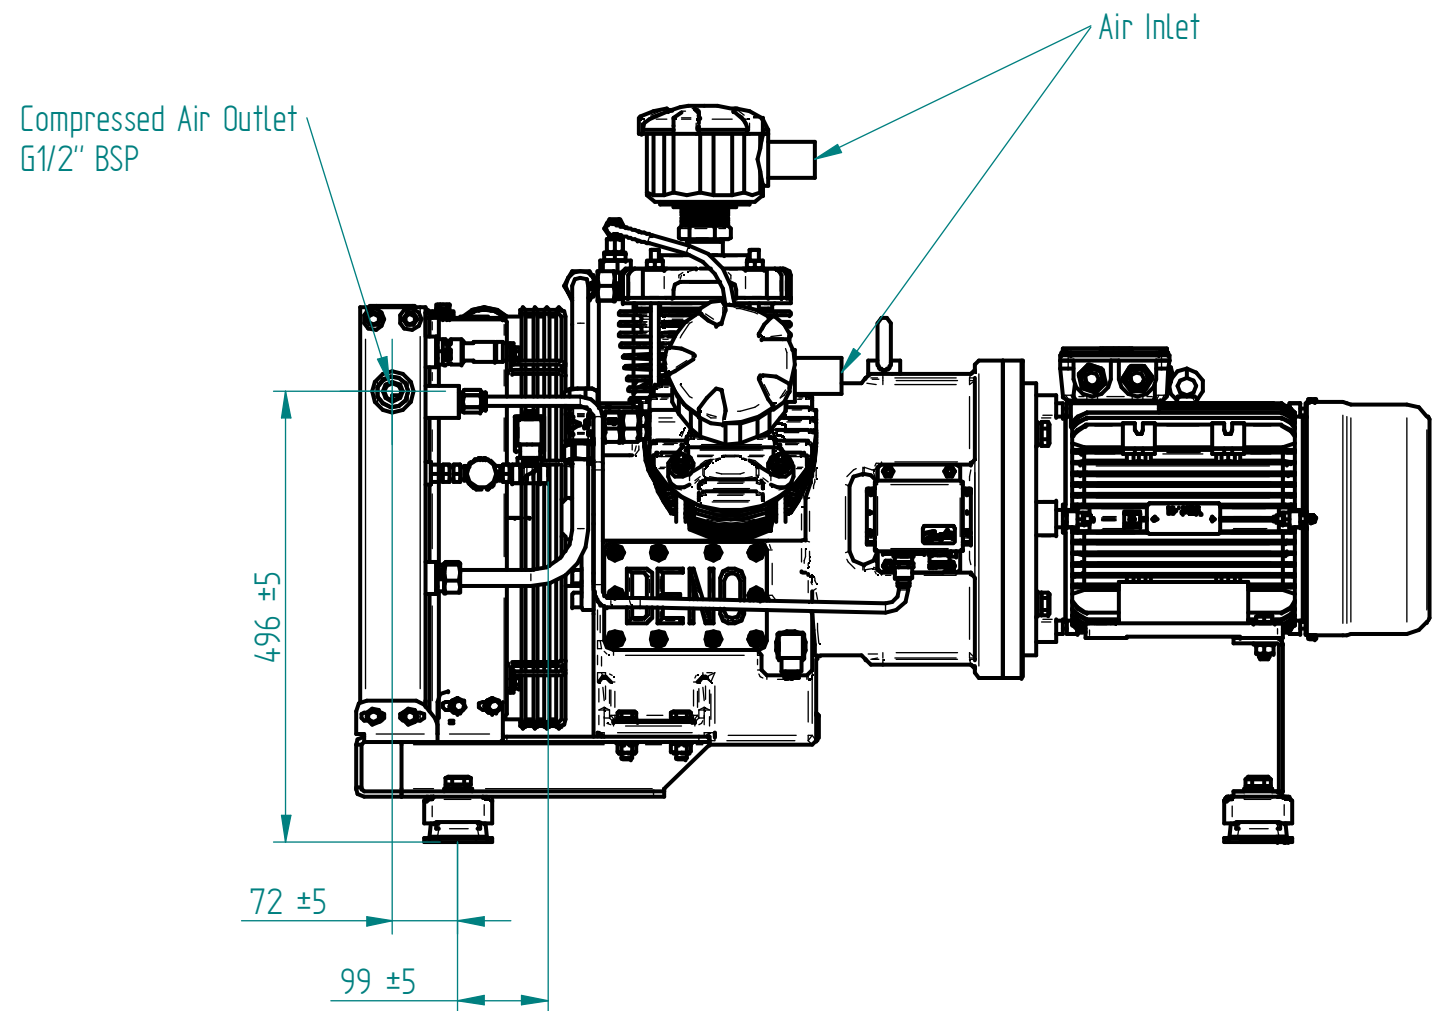


### Positions of Connections

	NAME:	DATE:
DRAWN:	EL	12/11/21
DRAWING TYPE:	General Arrangement	
DOCUMENT:	GA-3L-42-132M-Full Option.dft	

DENO compressors B.V.  
www.denocomp.nl  
info@denocomp.nl

SCALE: 1:10  
SIZE: A3

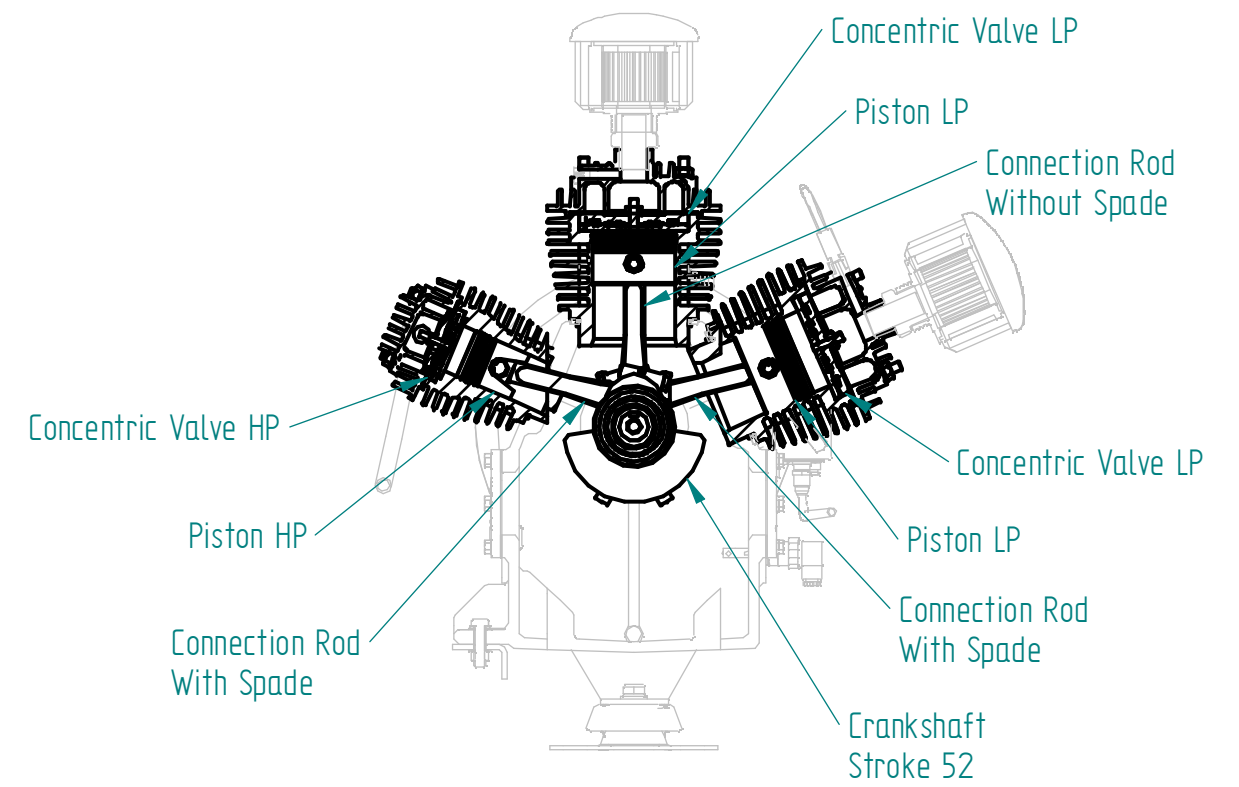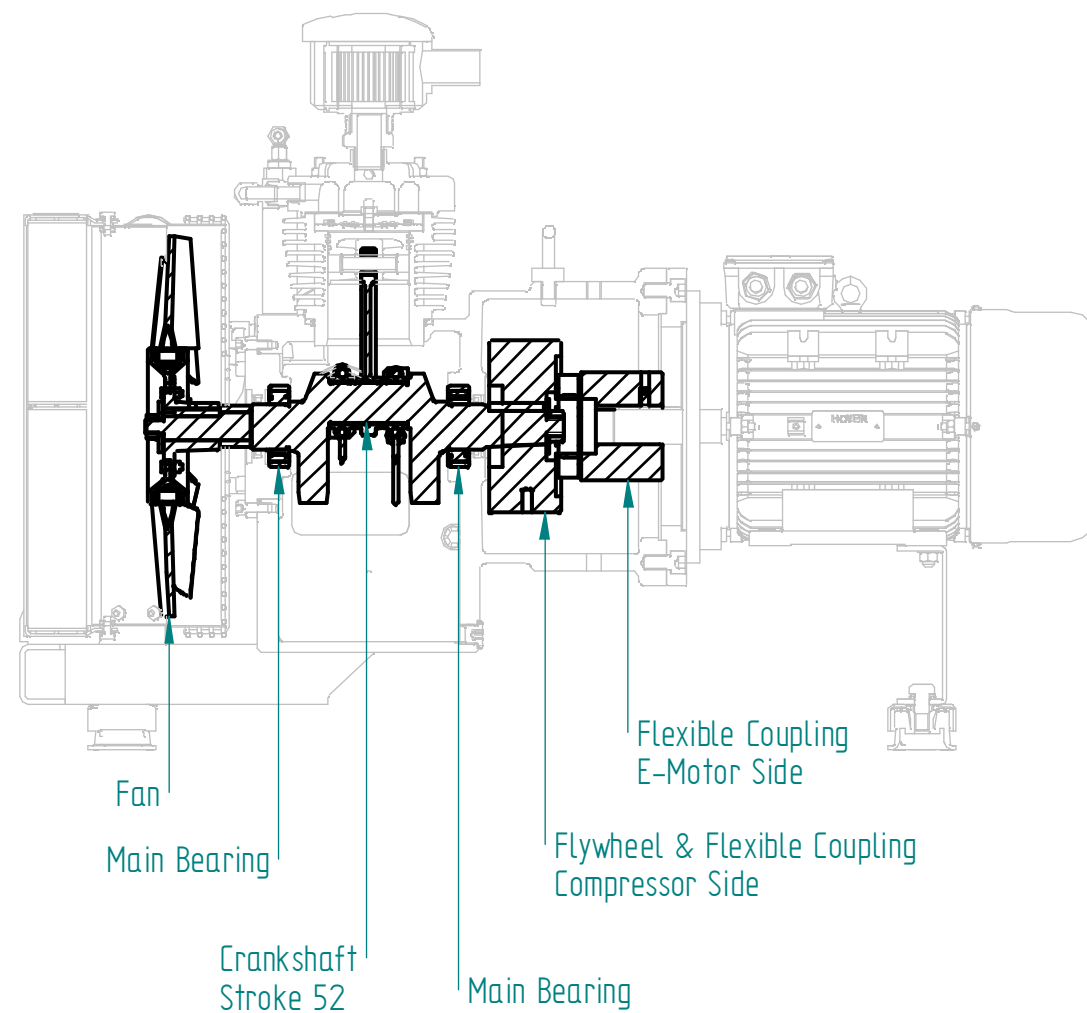


## Section Views

	NAME:	DATE:
DRAWN:	EL	12/11/21
DRAWING TYPE:	General Arrangement	
DOCUMENT:	GA-3L-42-132M-Full Option.dft	

DENO compressors B.V.  
 www.denocomp.nl  
 info@denocomp.nl

SCALE: 1:10  
 SIZE: A3

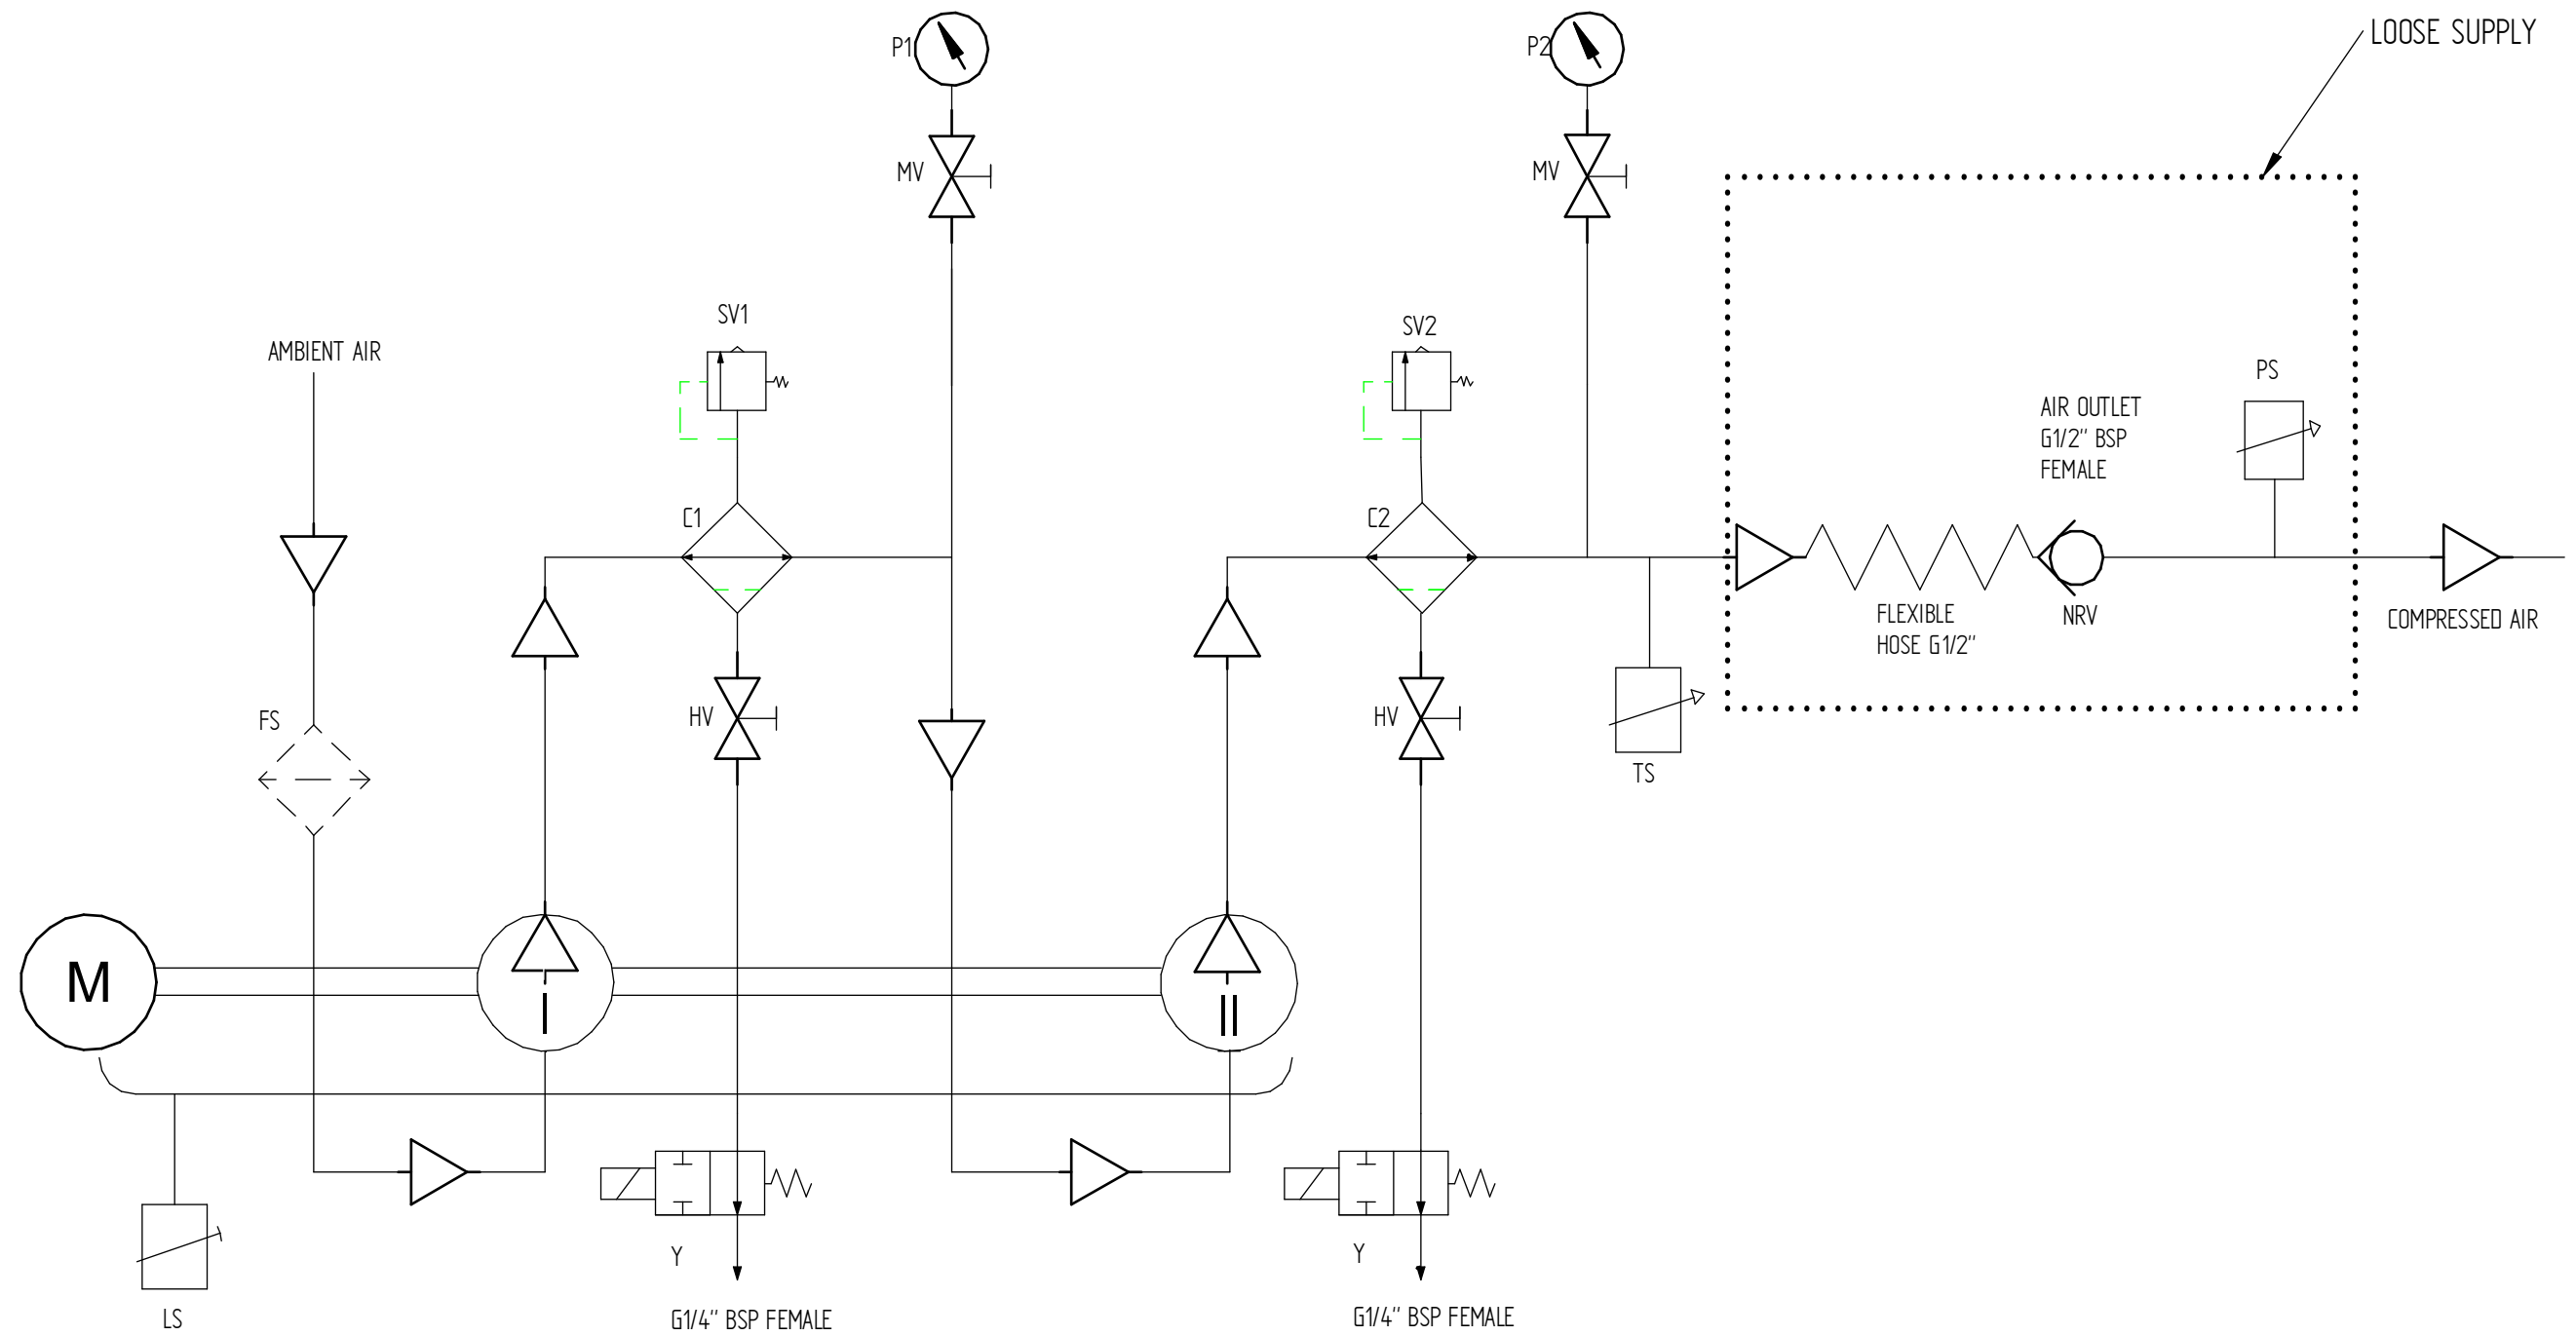

LEGEND P&I DIAGRAM:

FS	FILTER & SILENCER	NRV	NON -RETURN VALVE
M	E-MOTOR	MV	MANUAL VALVE
I	COMPRESSOR STAGE 1	HV	MANUAL DRAIN VALVE
II	COMPRESSOR STAGE 2	PS	PRESSURE SWITCH
C1	INTER COOLER WITH INTEGRATED OIL-WATER SEPARATOR	TS	TEMPERATURE SWITCH
C2	AFTER COOLER WITH INTEGRATED OIL-WATER SEPARATOR	LS	OIL LEVEL SENSOR
SV1	SAFETY VALVE STAGE 1	Y	SOLENOIDS
SV2	SAFETY VALVE STAGE 2		
P1	PRESSURE GAUGE STAGE 1		
P2	PRESSURE GAUGE STAGE 2		

NAME:		DATE:	
DRAWN:	EL		31/05/21
DRAWING TYPE:	Piping and Instrumentation Diagram		
COMMENTS:	-		



P&ID

DENO compressors B.V.  
www.denocomp.nl  
info@denocomp.nl

SIZE: A3